

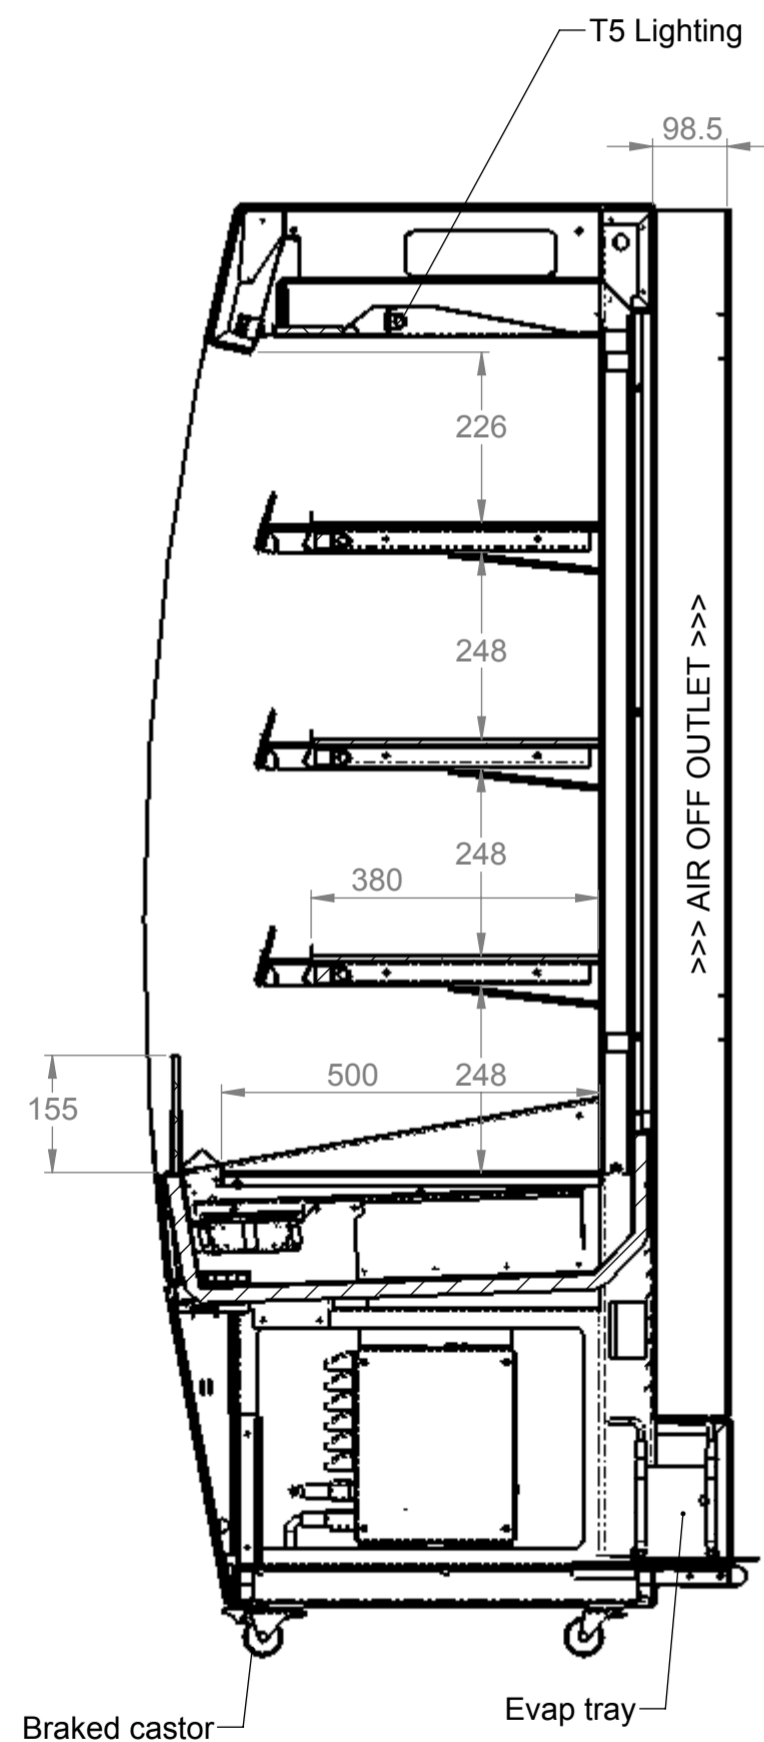


Plan

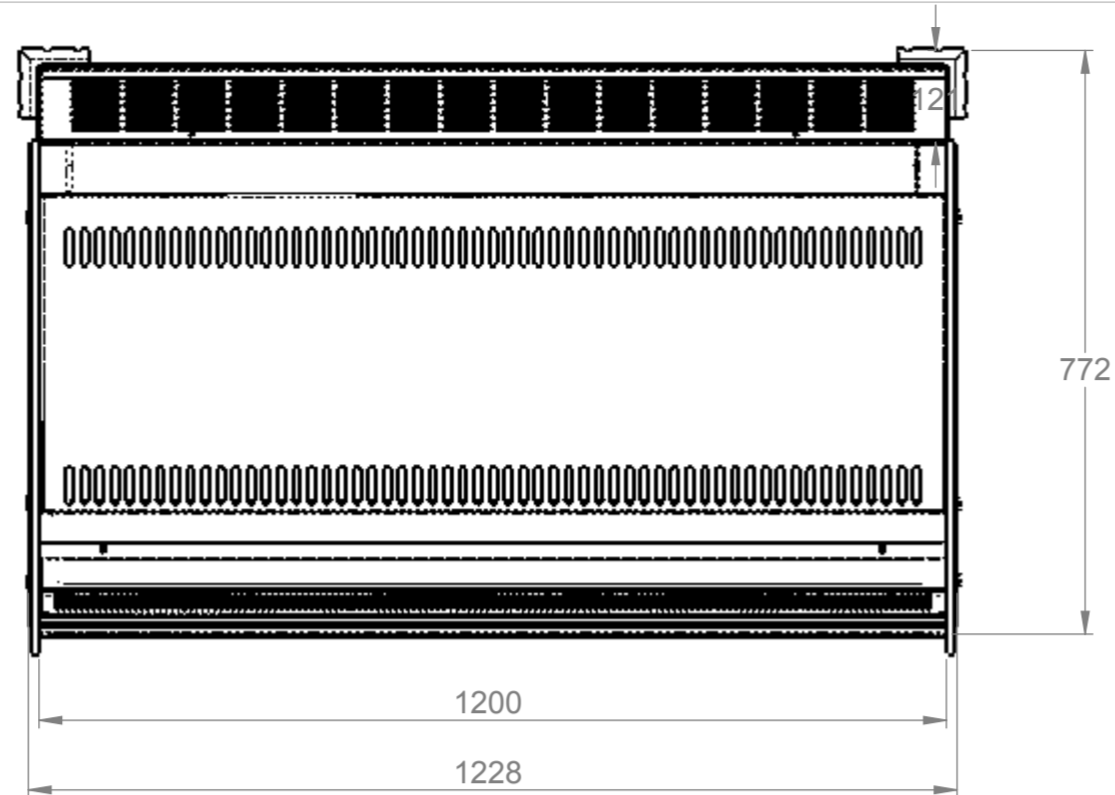


SECTION A-A


Front elevation

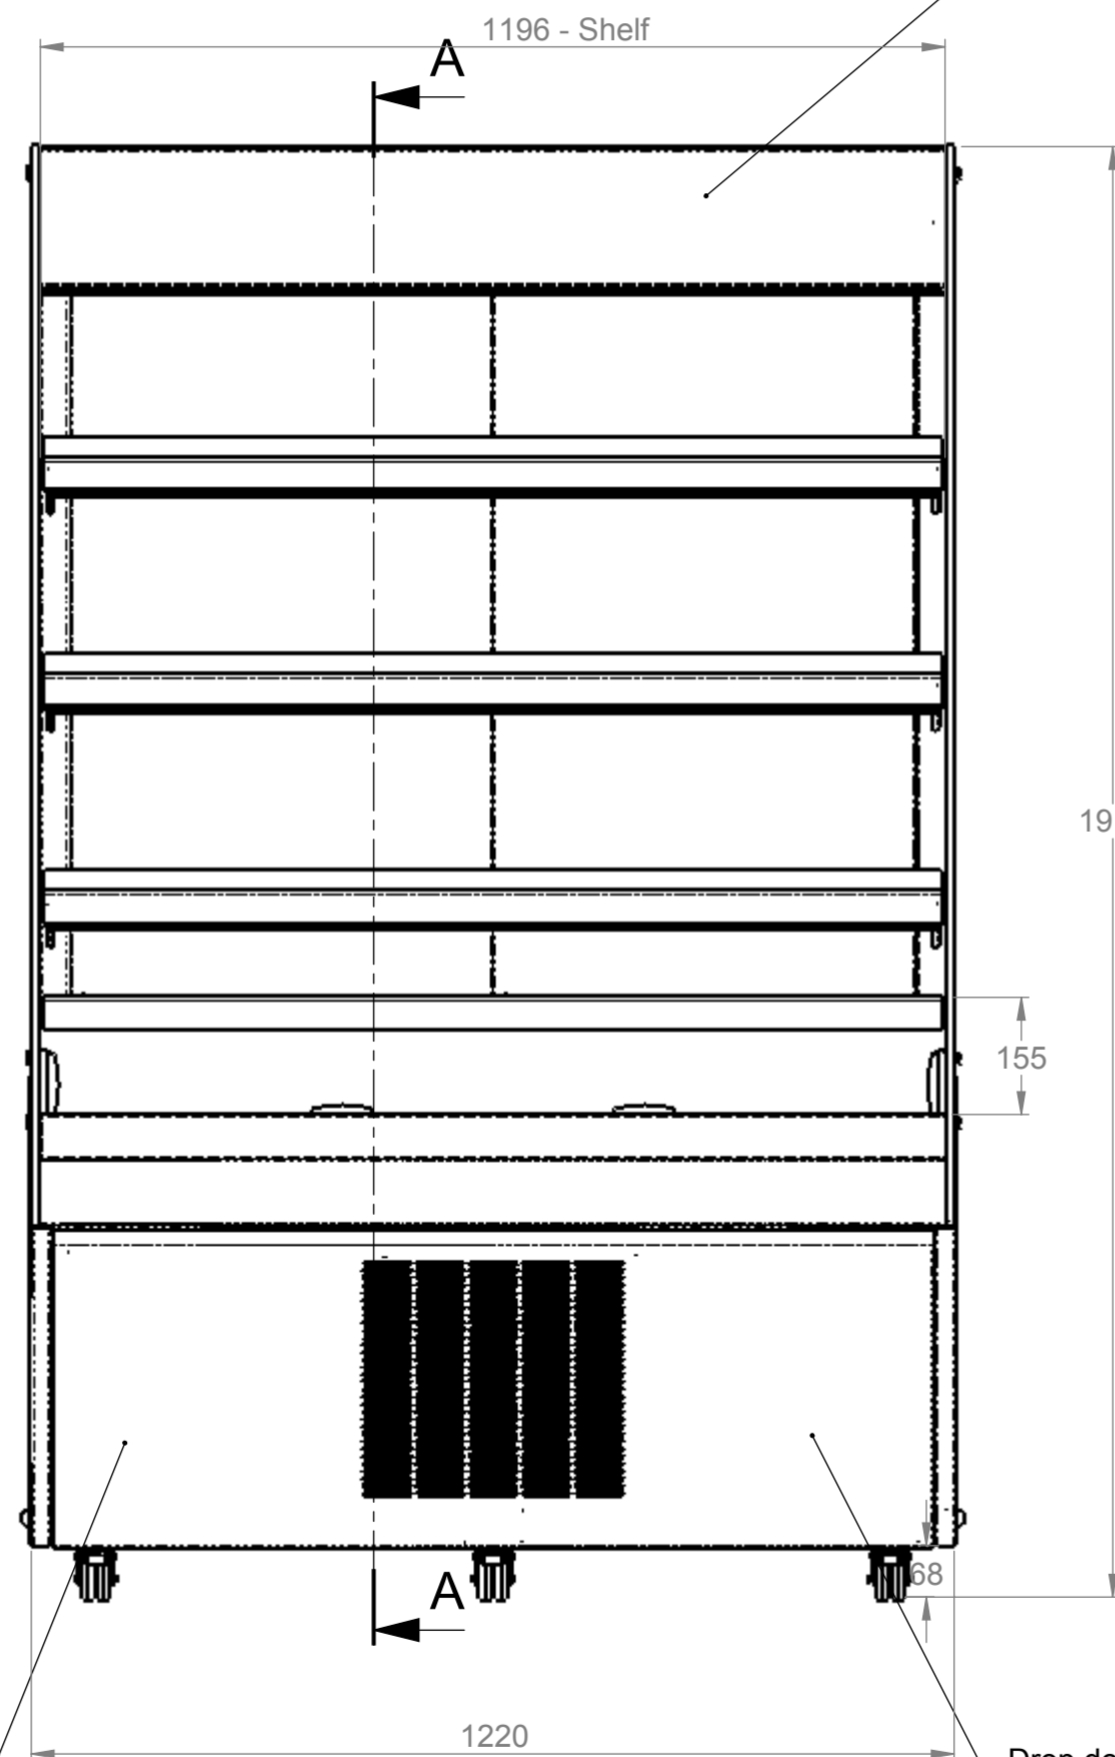

End elevation

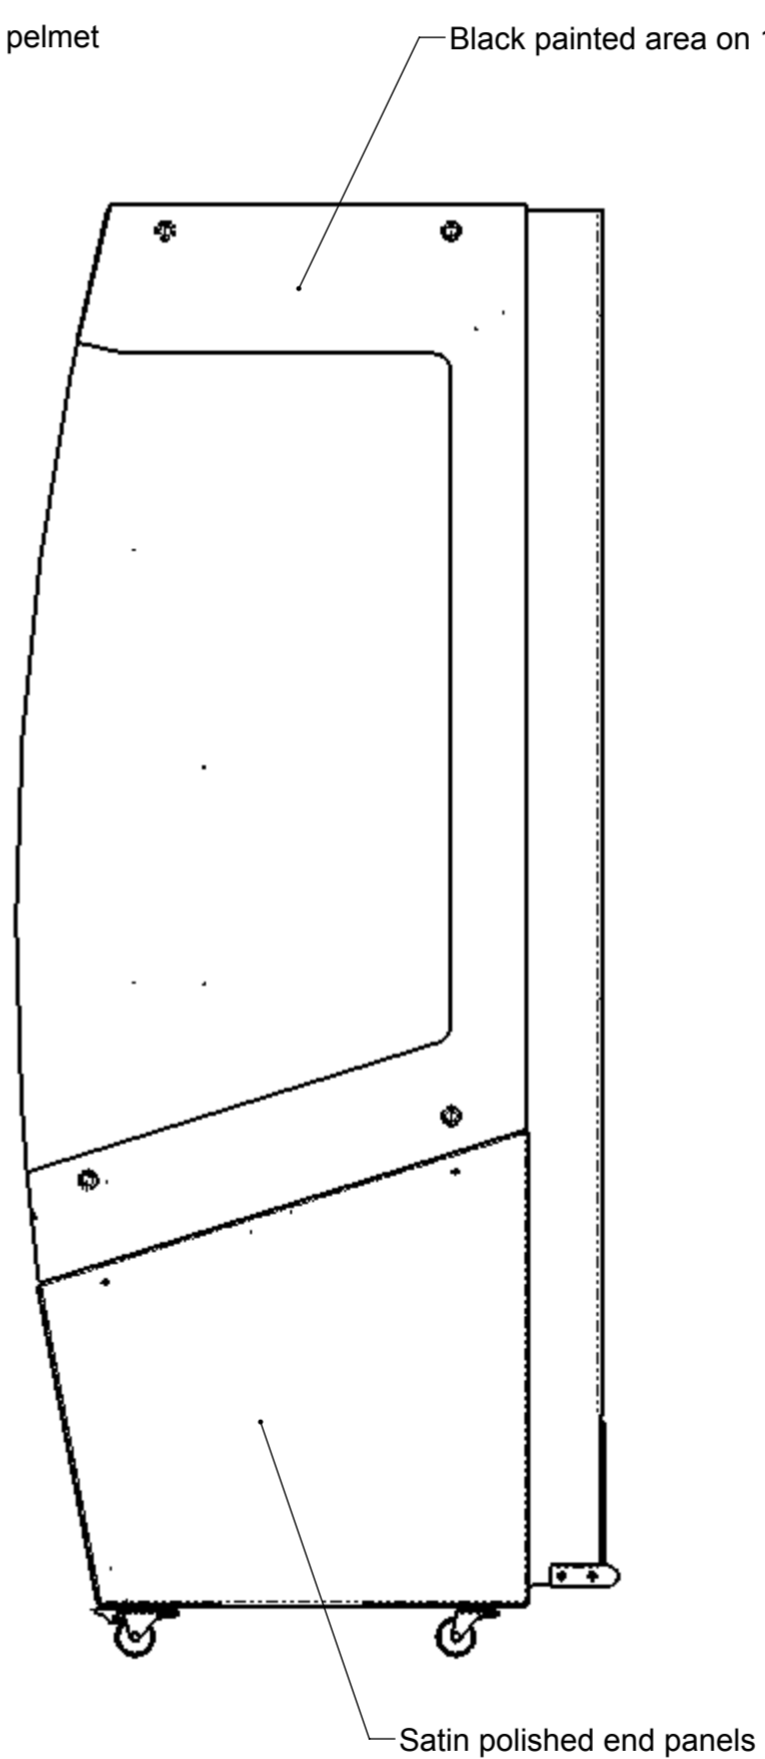

Rear elevation

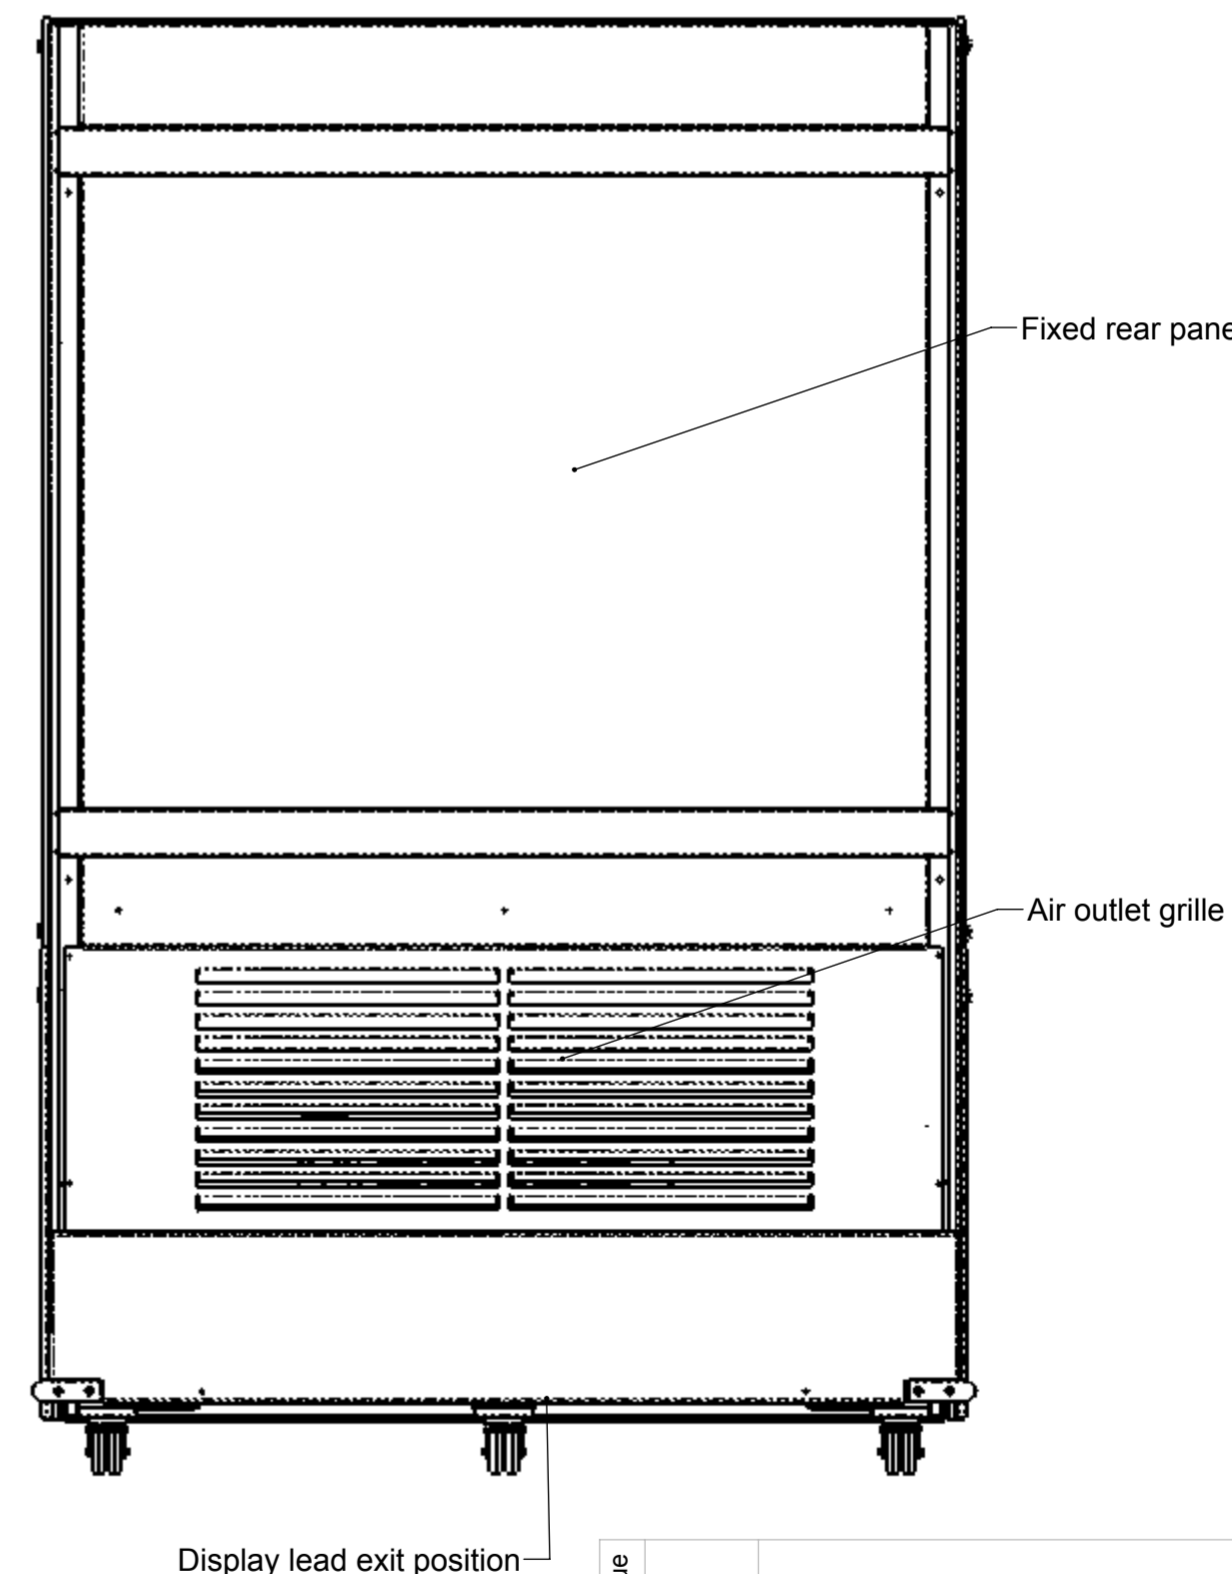

Electrical info:- 13 Amp 230V 2.5Kw
 Display supplied with 13 Amp plugtop on 1500 Long lead
 Weight - 196Kg Approx

Assembly No - EDC1200

Issue	Date	Description
<p>Randles Rd, Knowsley Business Park, Merseyside L34 9HZ. Tel: 0151 548 2211 Fax: 0151 549 2179</p>		
Title: Chilled Multi Level 1200 - Straight Shelf - FB		
Drg No :	Issue:	Date: 24/06/2015
12-201--A		Scale: 1:10 @ A2
		Chk'd:
Drn by: G Burgess	All dims in MM	Date: