




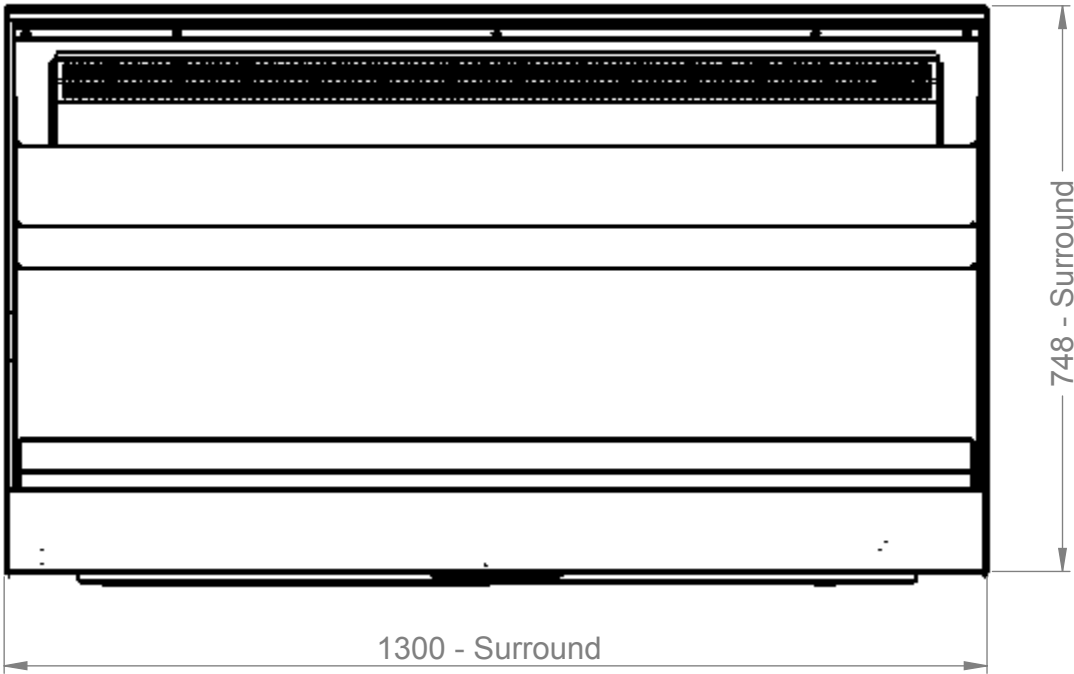


Plan

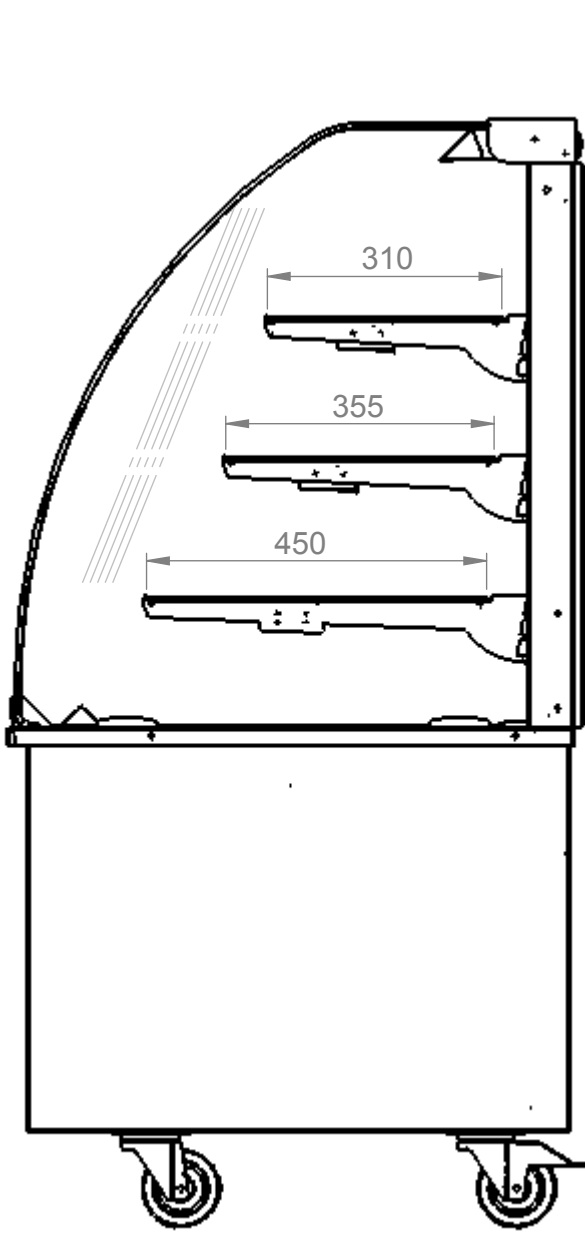


End elevation

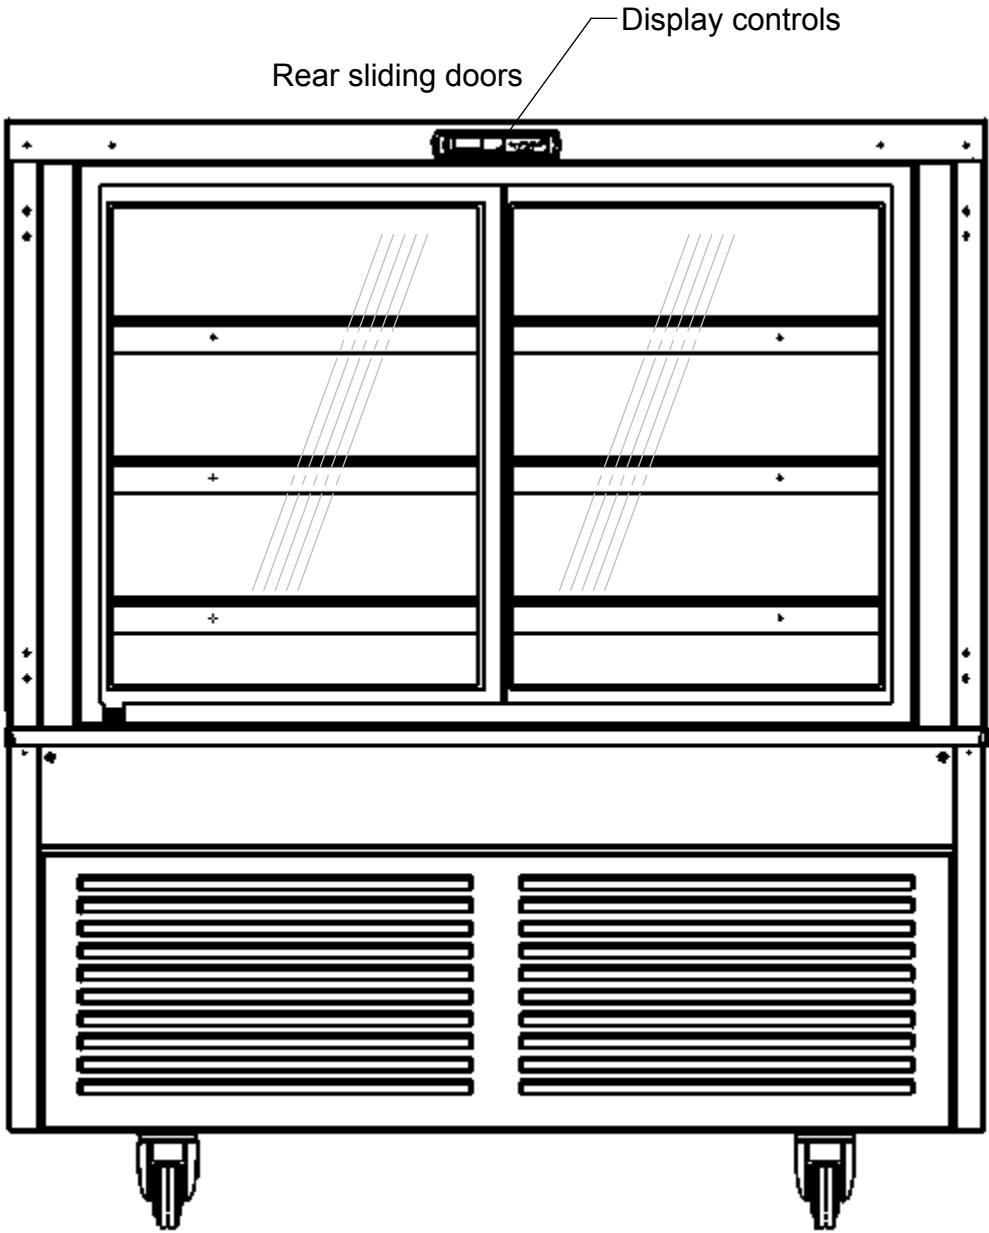

Rear elevation

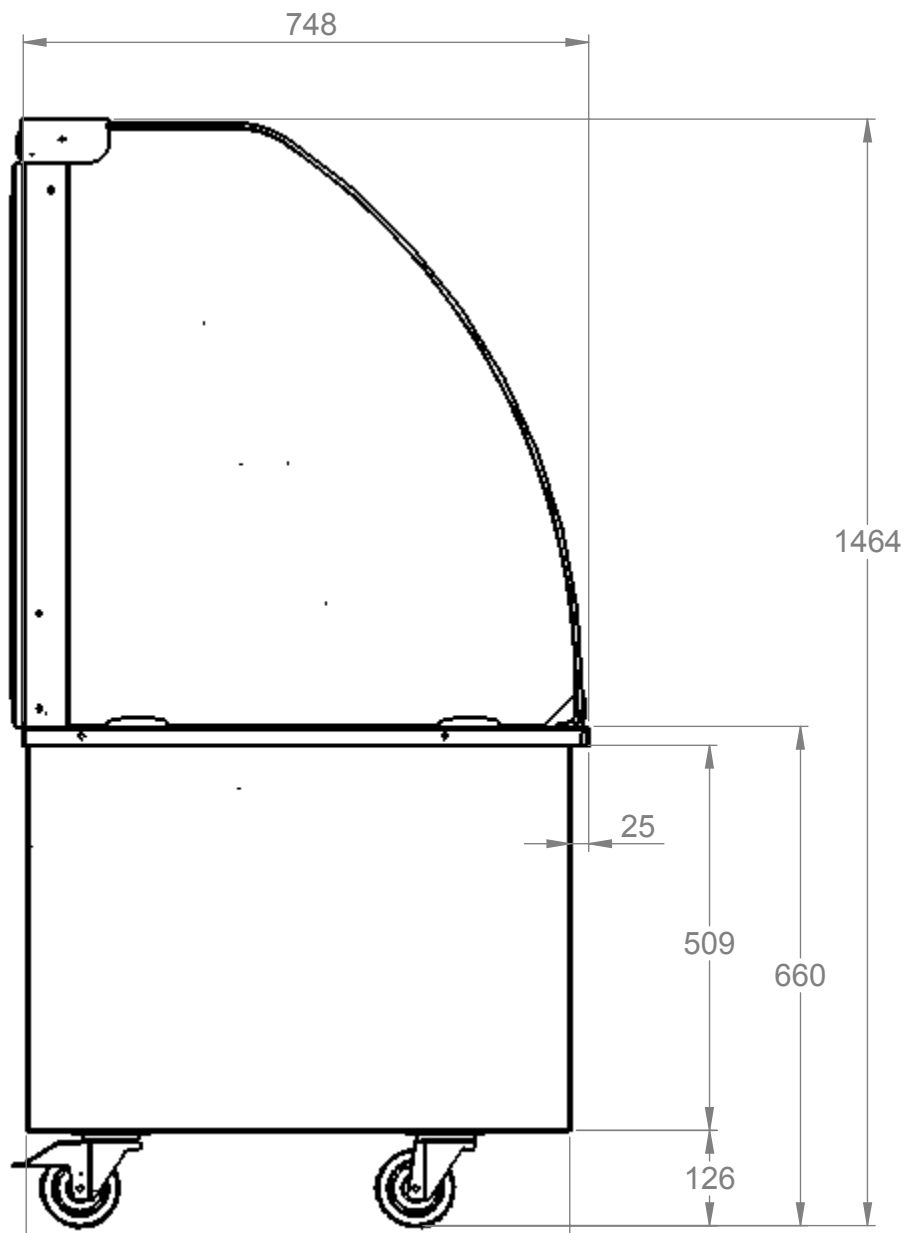

End elevation

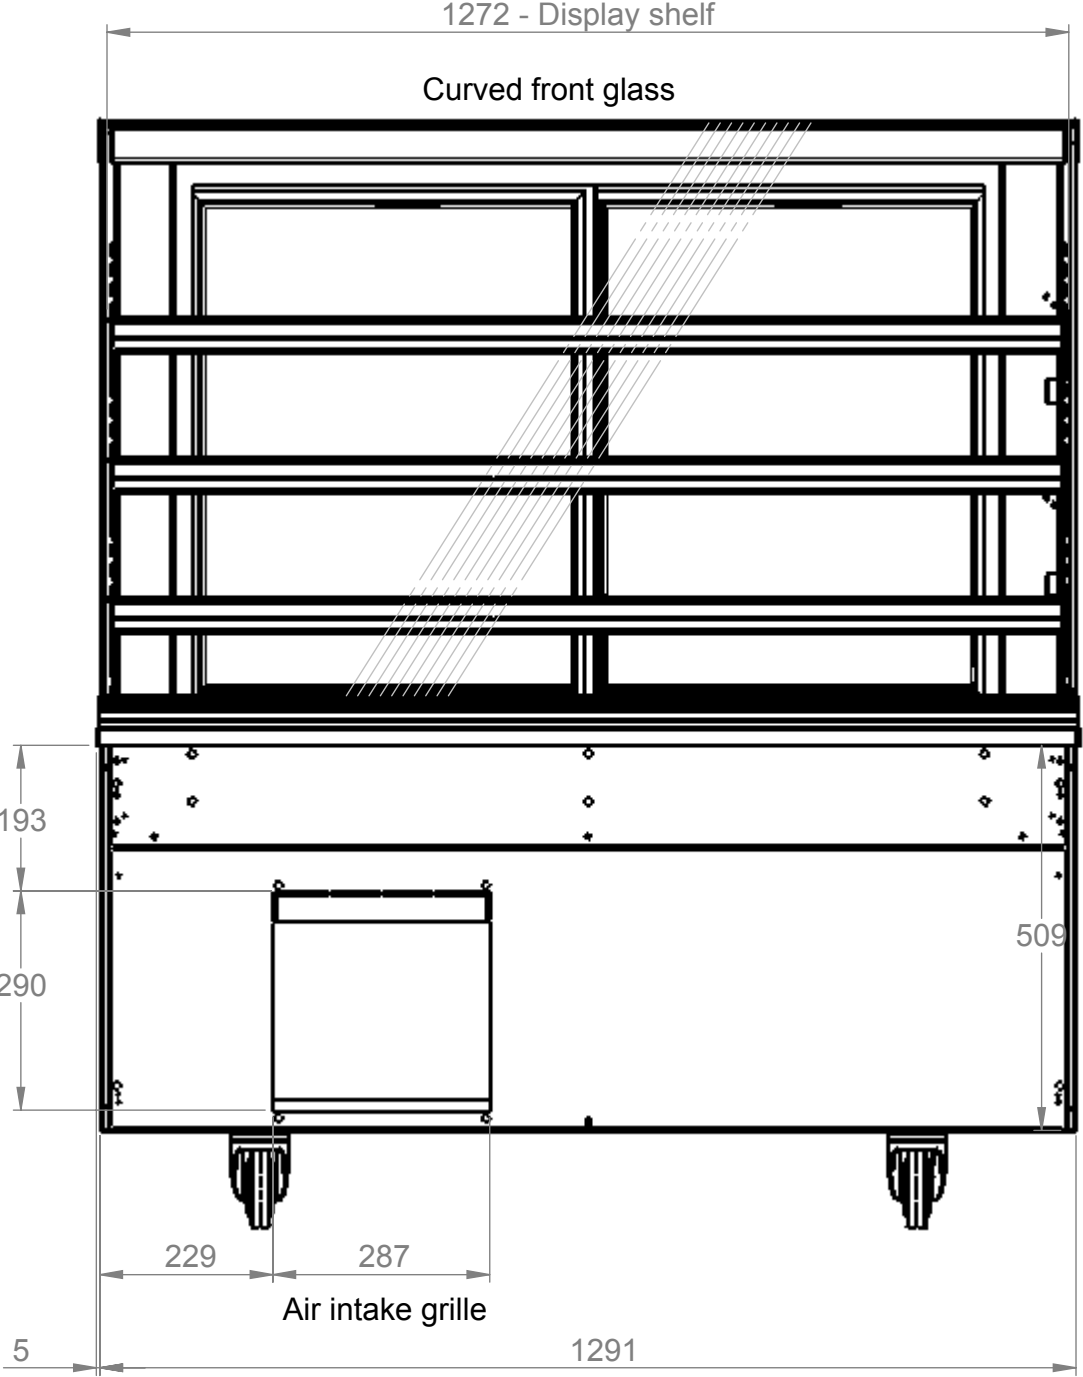

Front elevation

Electrical Spec - 13A, 230V, 2.3Kw
via 13 Amp plugtop on 2.5 Metre lead
Weight - 252Kg Approx

Assembly No - VC1300-GO

Issue	Date	Description
counterline Randles Rd, Knowsley Business Park, Merseyside L34 9HZ. Tel: 0151 548 2211 Fax: 0151 549 2179		
Title: Vision Enclosed Chilled Display 1300		
Drg No : 14-233--A		Issue: Date: 06/01/2015
		Scale: 1:10 @ A2
		Chk'd:
Drn by: G Burgess	All dims in MM	Date: