
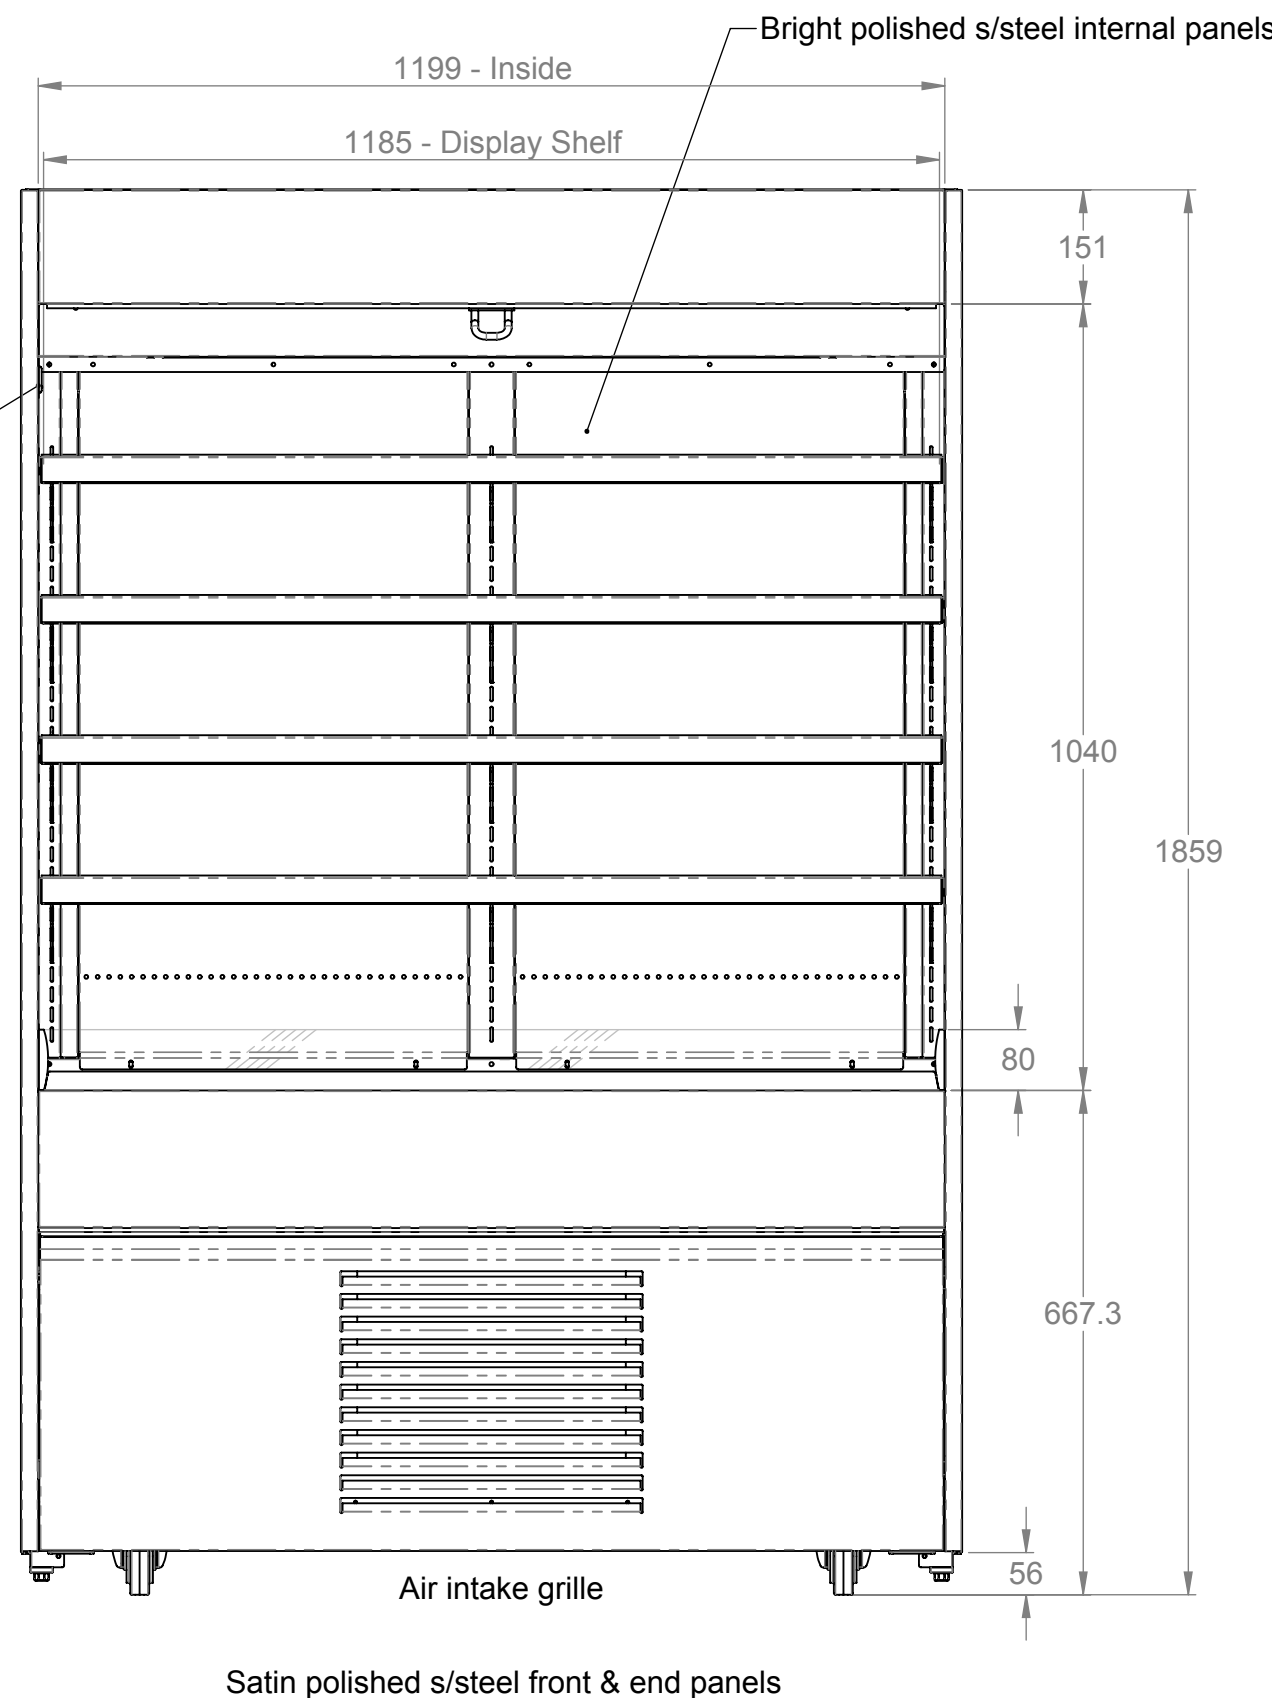
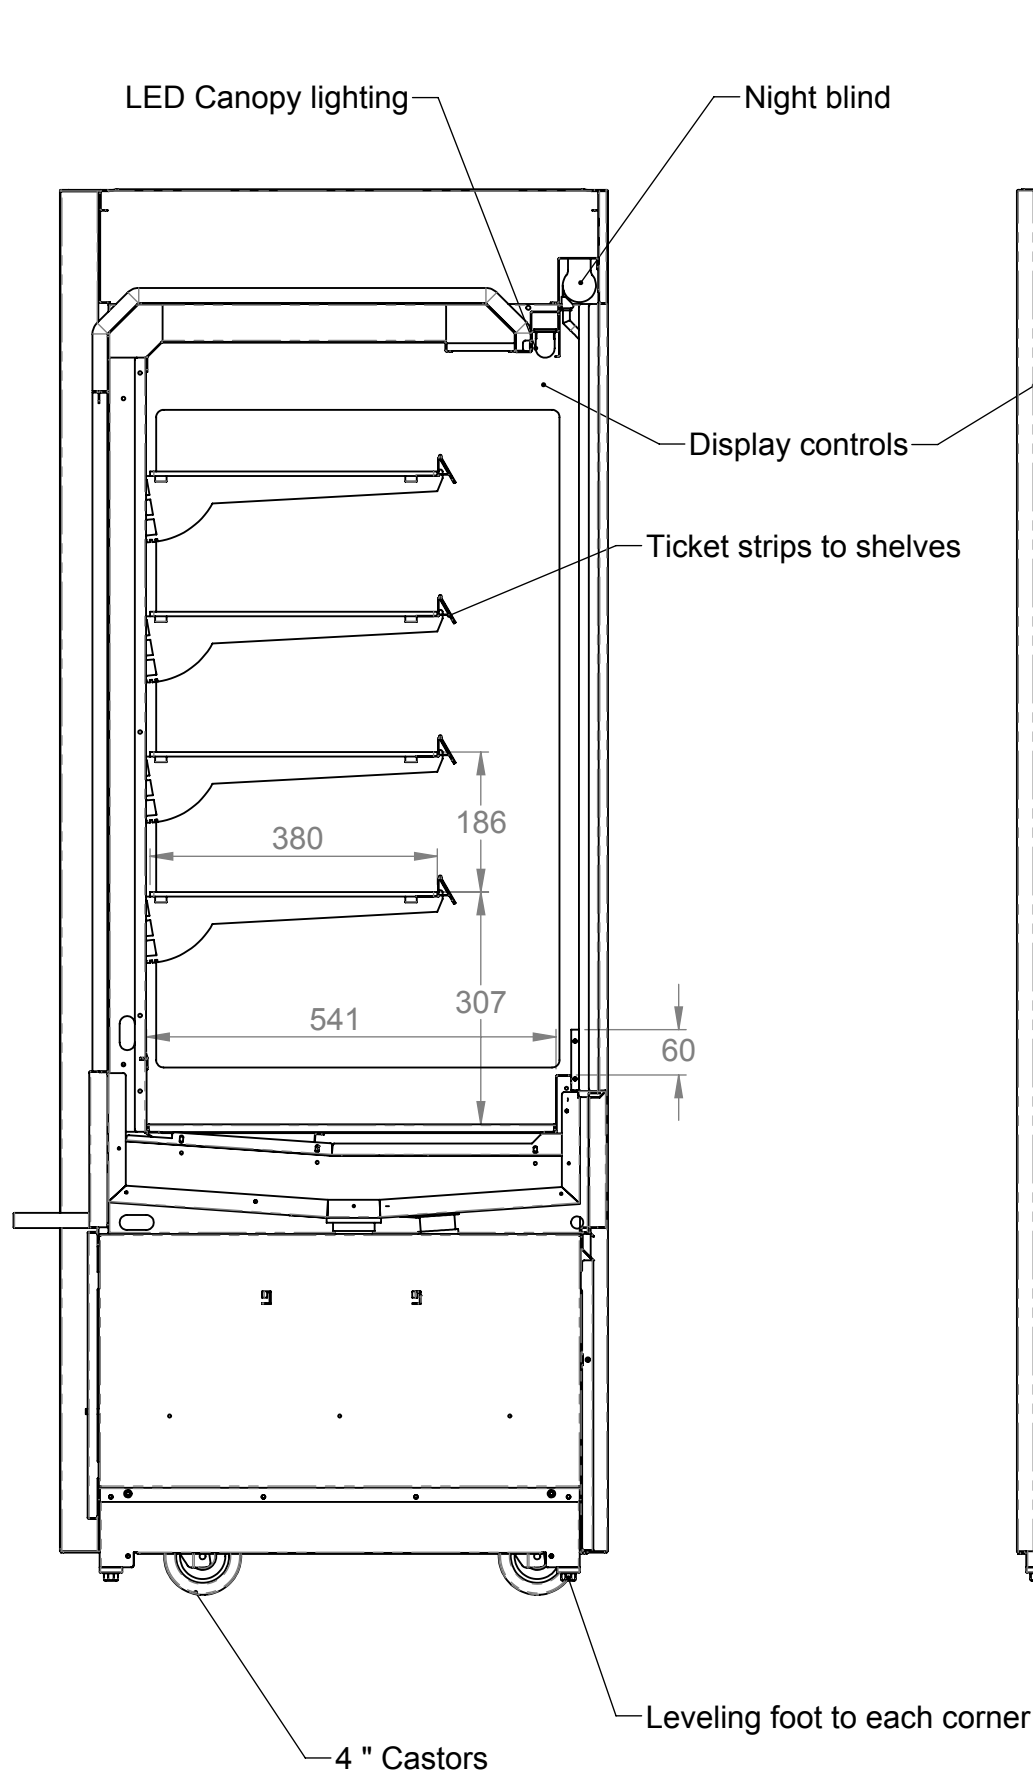



3rd Angle Projection.   
 This drawing and the information properties contained there on is the property of Counterline Ltd and must not be copied or issued to a third party without the prior consent of Counterline Ltd.




Plan



Front elevation

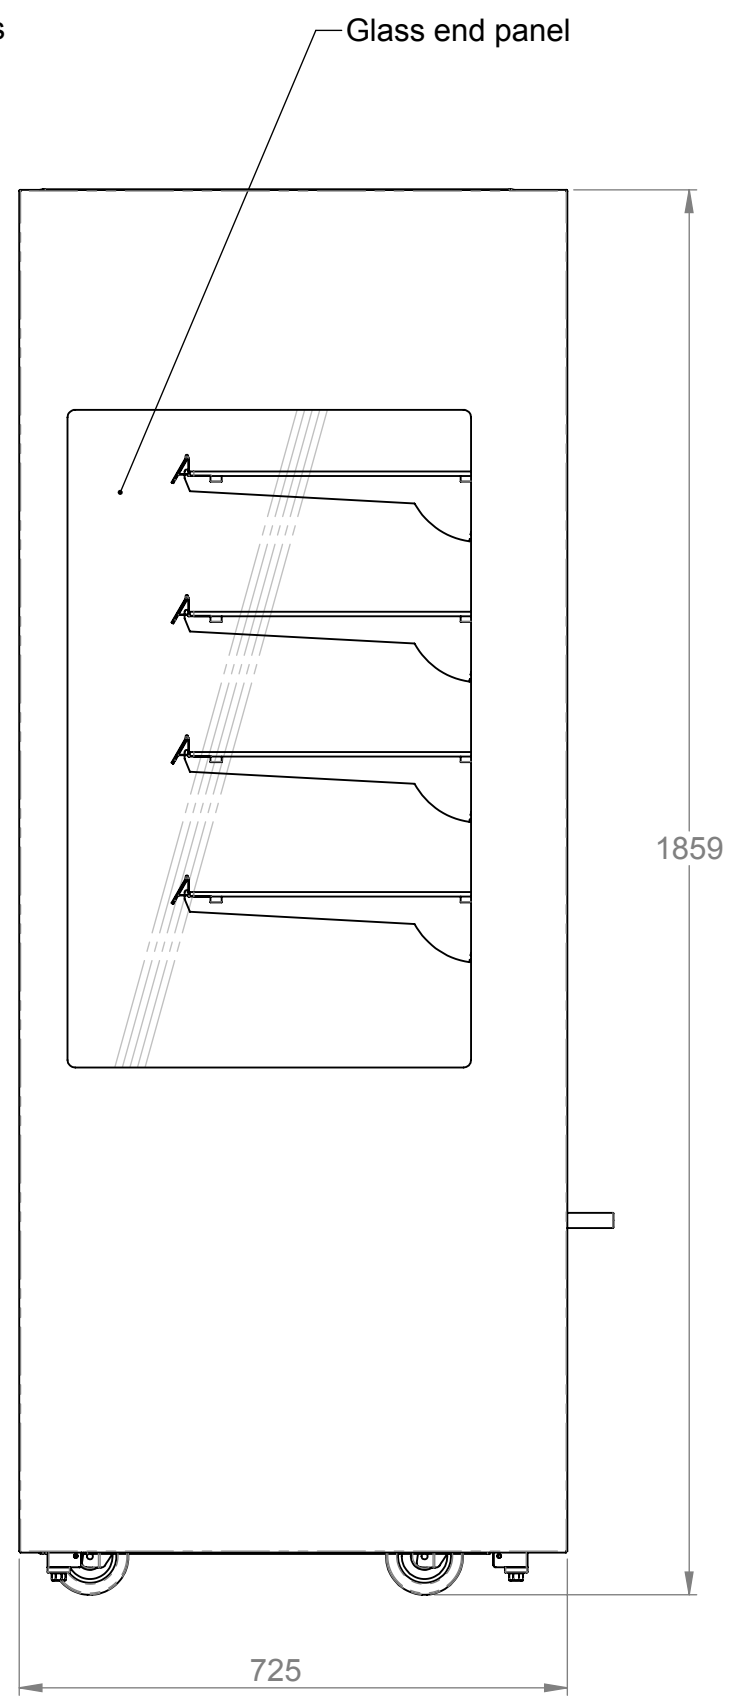


End elevation

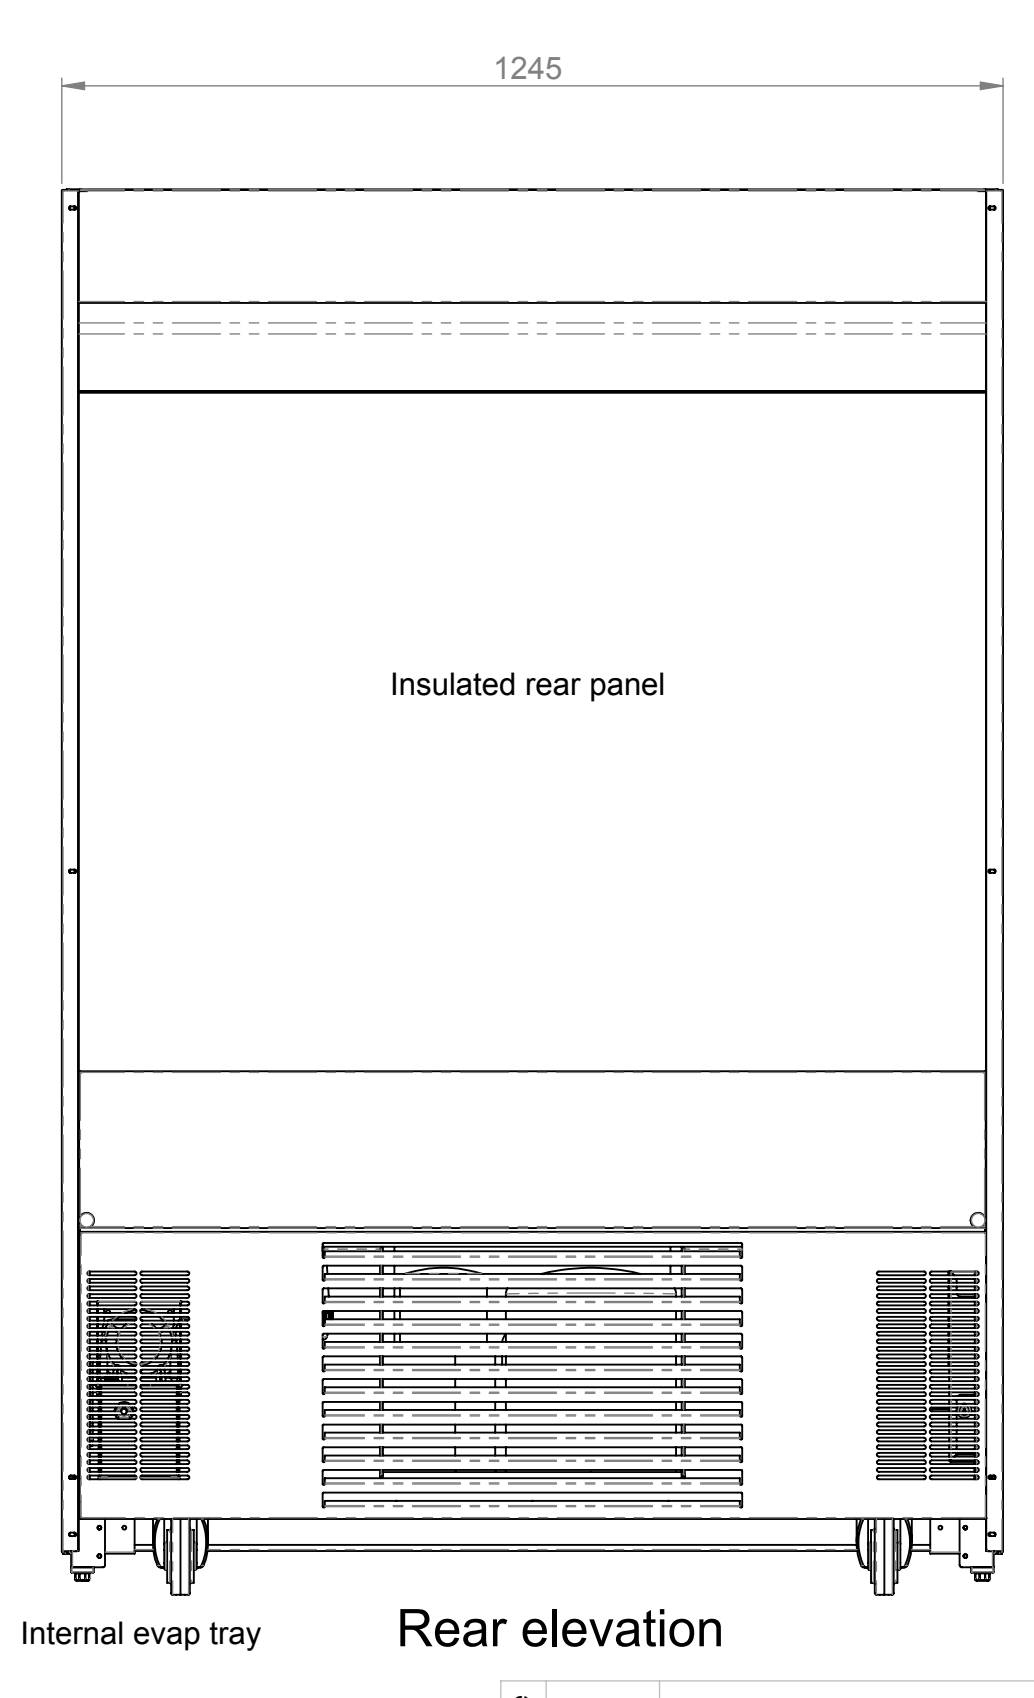

Rear elevation

ELECTRICAL SPEC - 13A, 230V, 2.7Kw  
 Via 13 Amp plugtop on 2.5 Metre lead  
 Weight - 200 Kg Approx

Assembly No - CHCMD12-NB-GE

| Issue   | Date           | Description      |
|---|----------------|------------------|
| <br>Randles Rd, Knowsley Business Park, Merseyside L34 9HZ.<br>Tel: 0151 548 2211 Fax: 0151 549 2179 |                |                  |
| Title: Chilled Multi Tier 1200  |                |                  |
| Drg No :  | Issue:         | Date: 23/06/2017 |
| 17-171--A   |                | Scale: 1:10 @ A2 |
|   |                | Chk'd:           |
| Drn by: G Burgess   | All dims in MM | Date:            |