
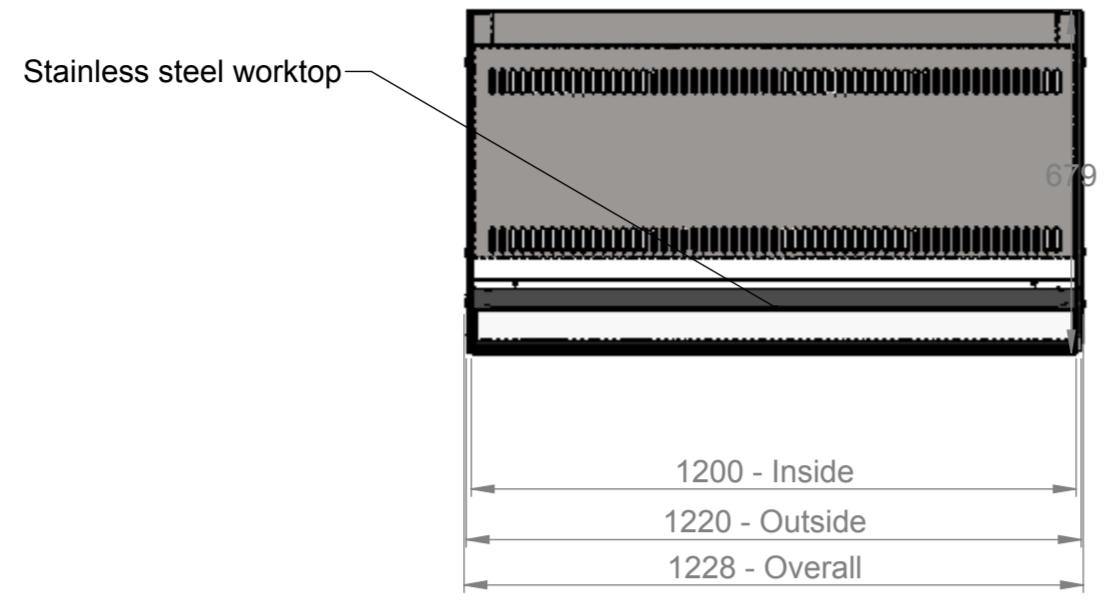
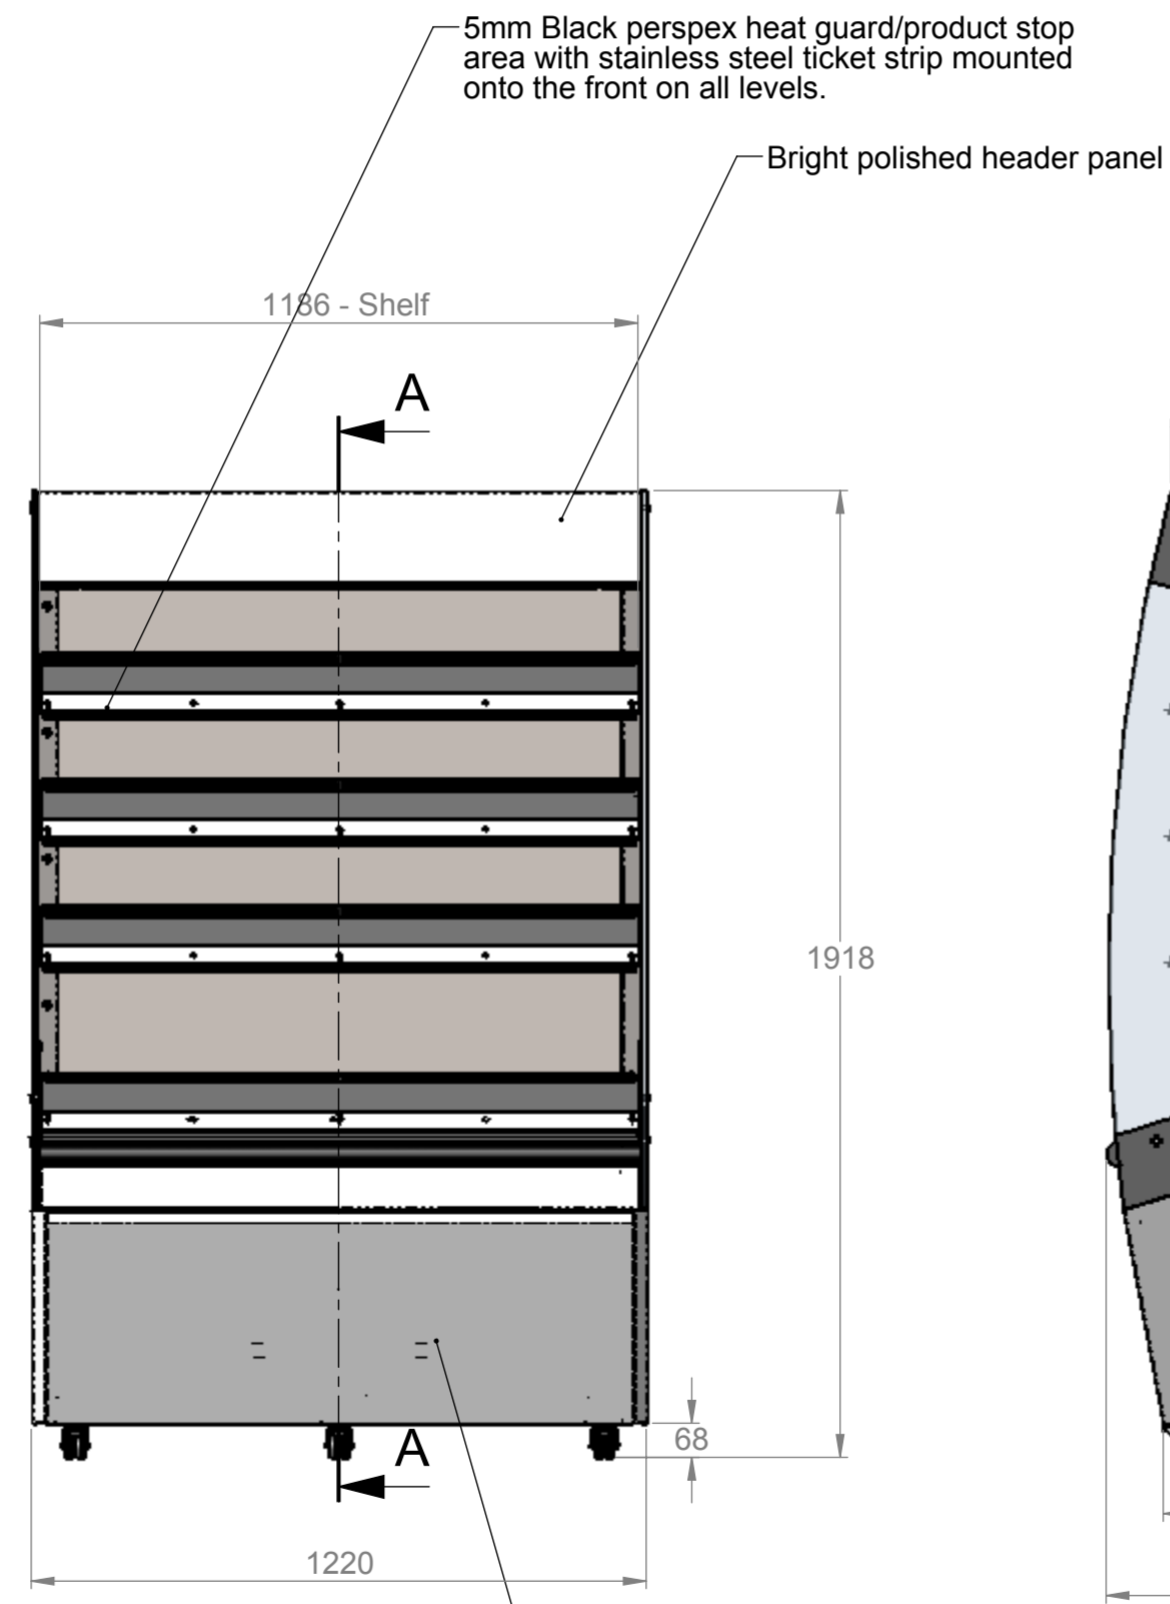
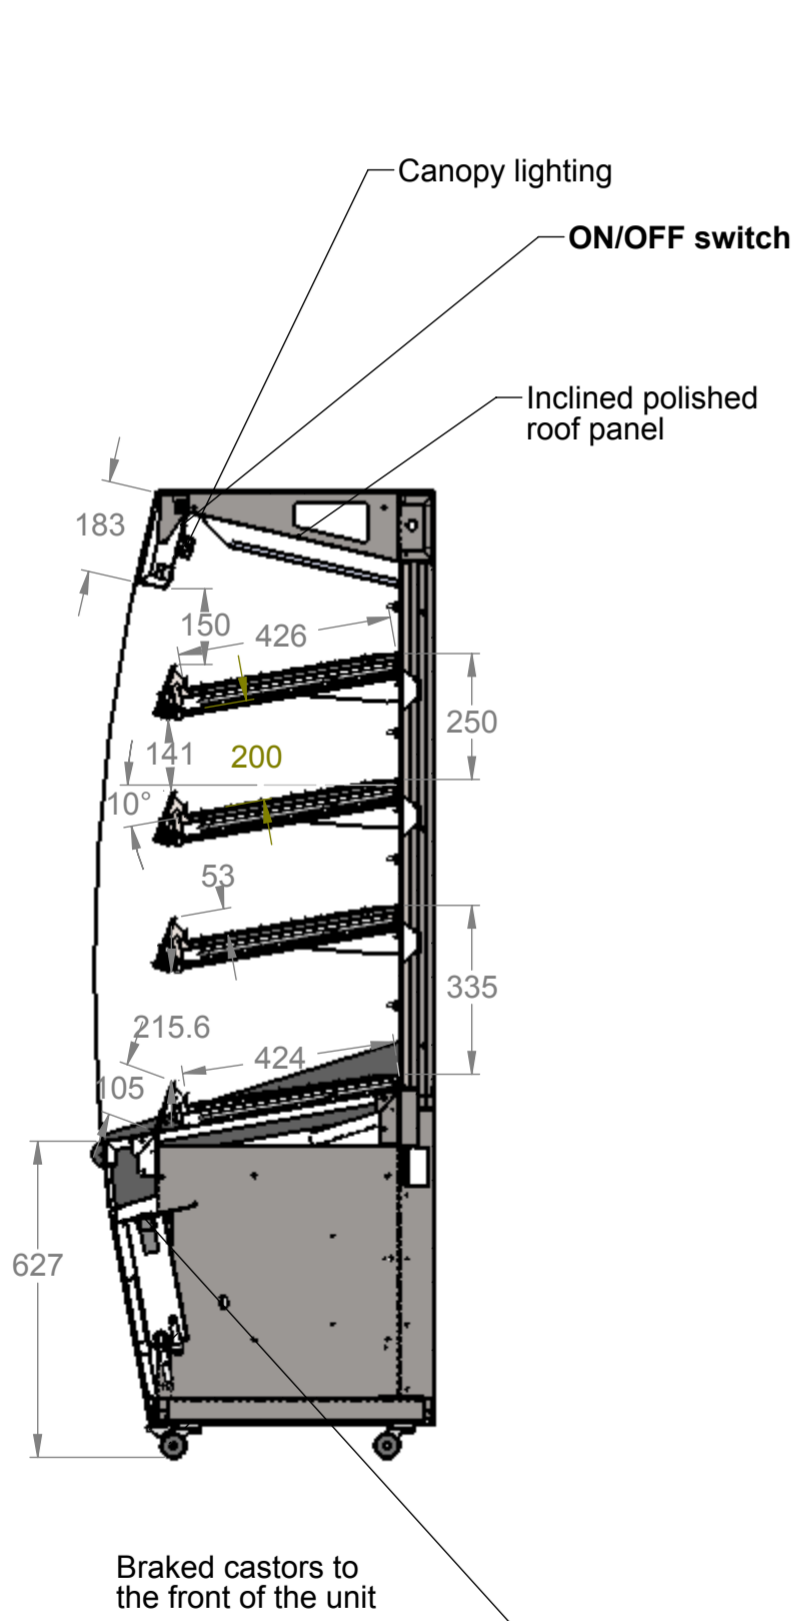



3rd Angle Projection. 
 This drawing and the information properties contained there on is the property of Counterline Ltd and must not be copied or issued to a third party without the prior consent of Counterline Ltd.



Plan




Front elevation

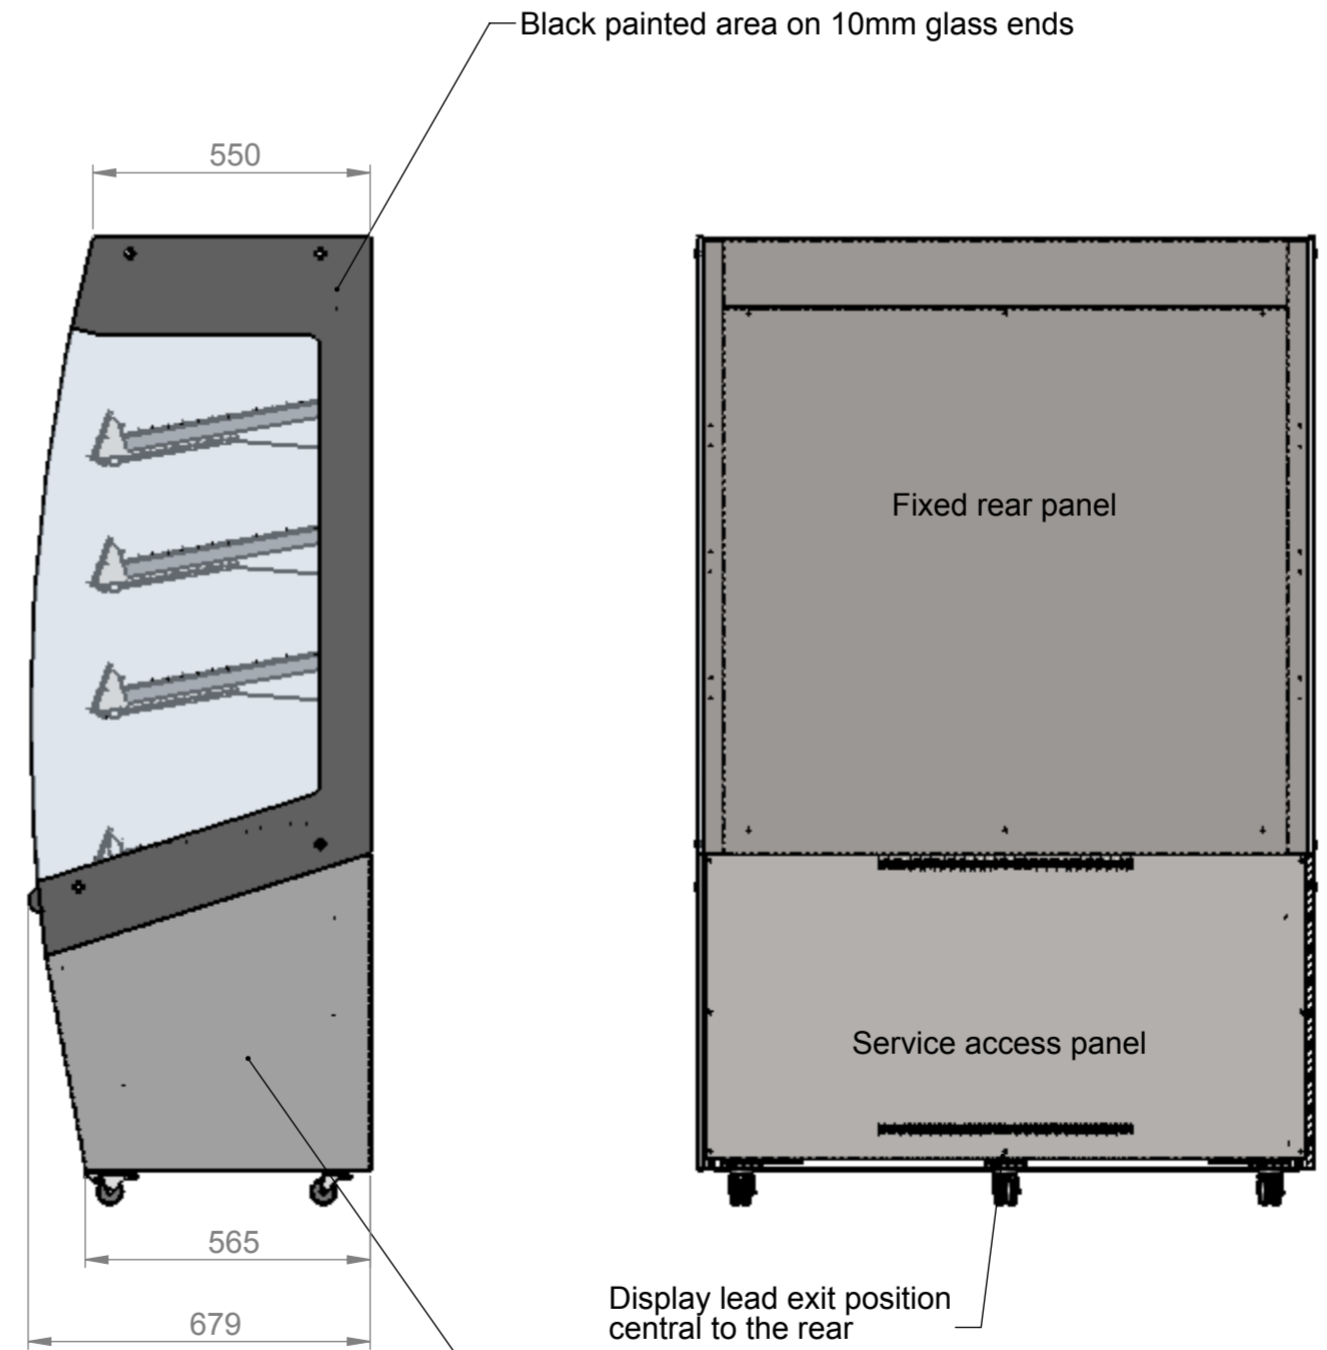

End elevation

Rear elevation

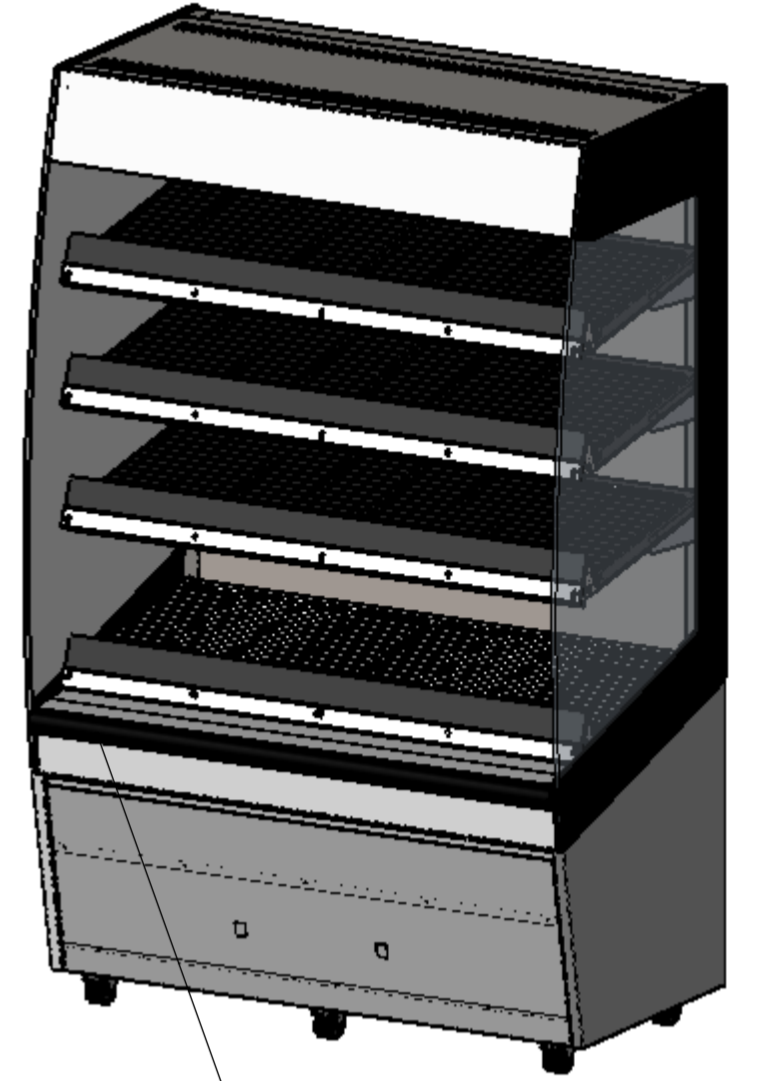


Isometric

50mm Black bumper rail

ELECTRICAL SUPPLY - 20 Amp 230 Volt (4Kw)

Stock Code - EHF1200

Issue	Date	Description
 Randles Rd, Knowsley Business Park, Merseyside L34 9HZ. Tel: 0151 548 2211 Fax: 0151 549 2179		
Title: Heated Multi Level 1200 Display		
Drg No :	Issue:	Date: 12/08/2014
12-126--A		Scale: 1:15 @ A2
		Chk'd:
Drn by: G Burgess	All dims in MM	Date: