




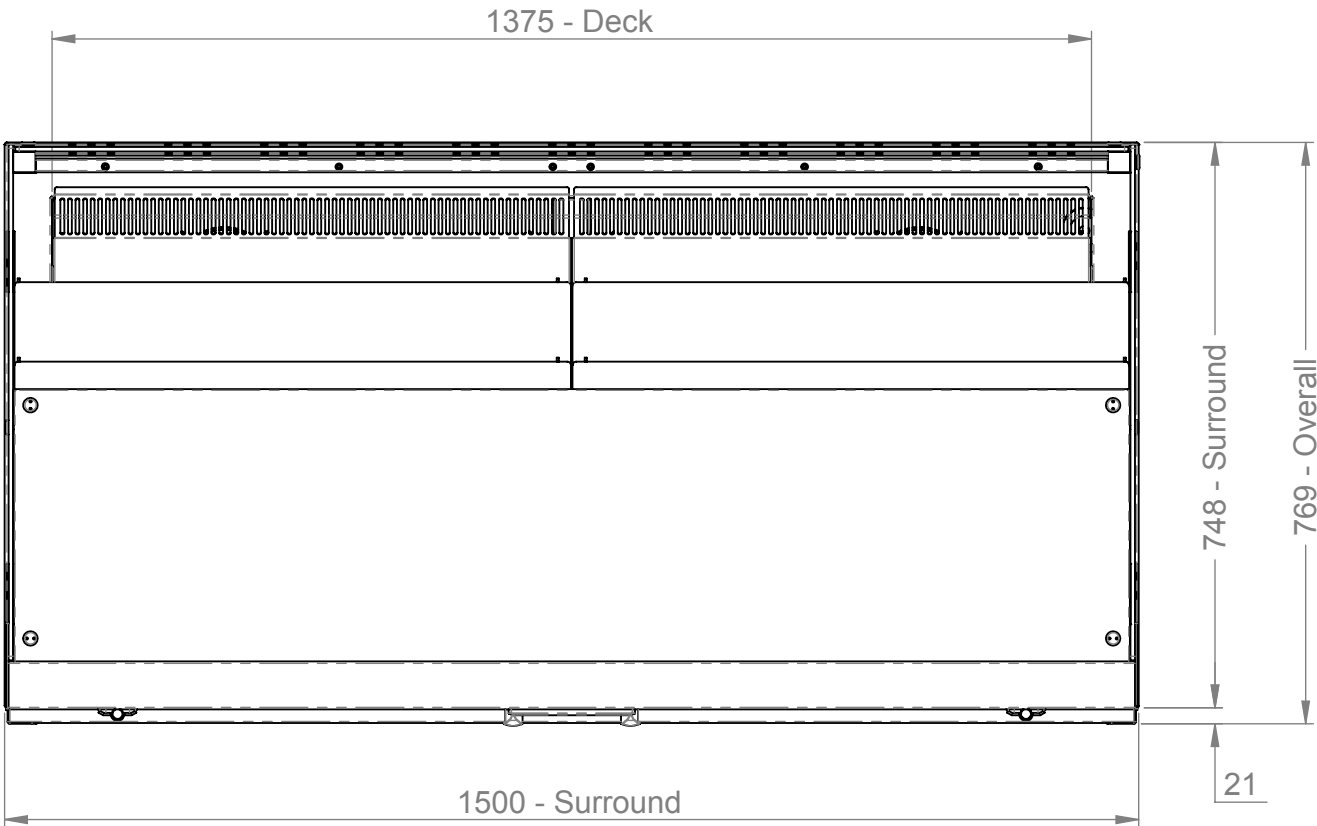


Plan

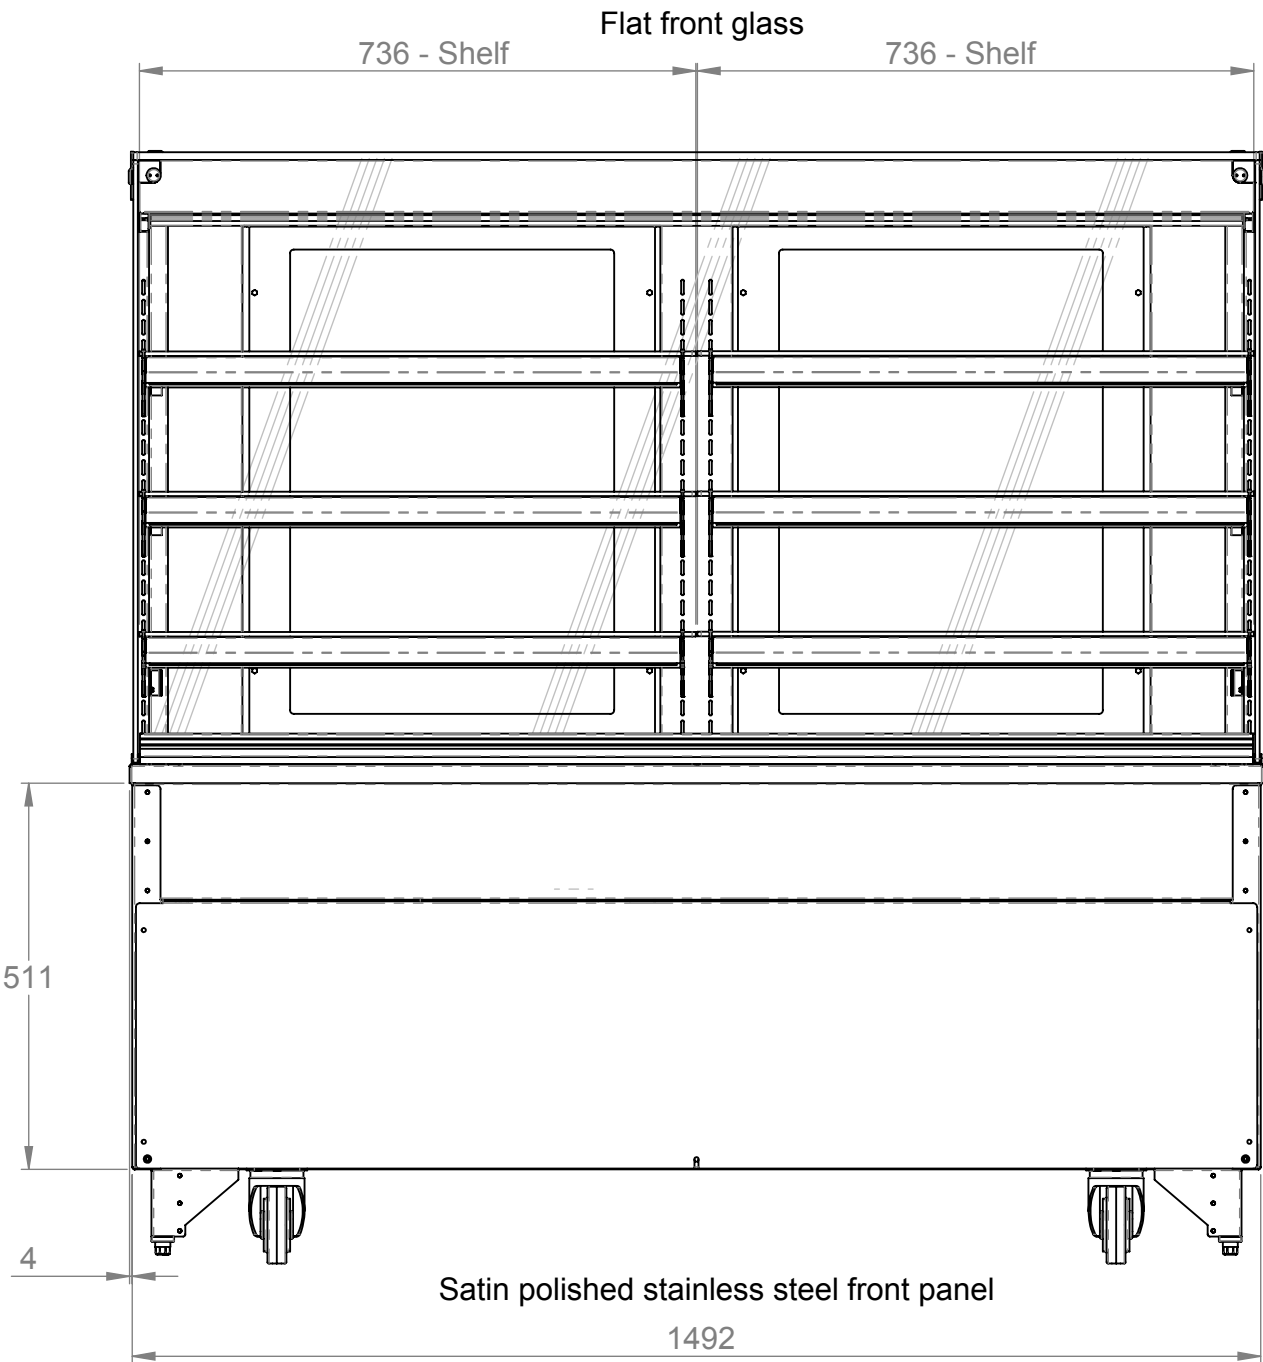


Front elevation

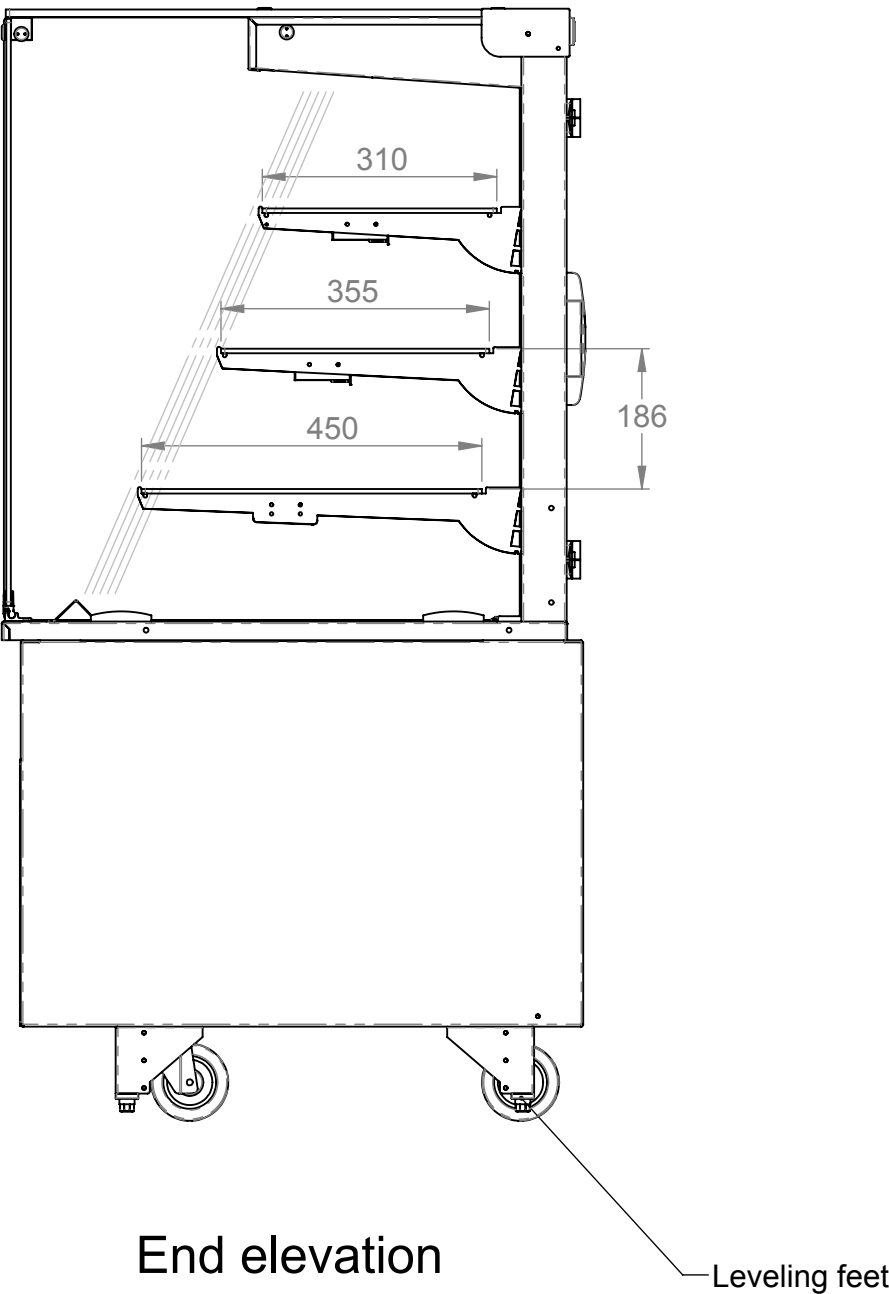

End elevation

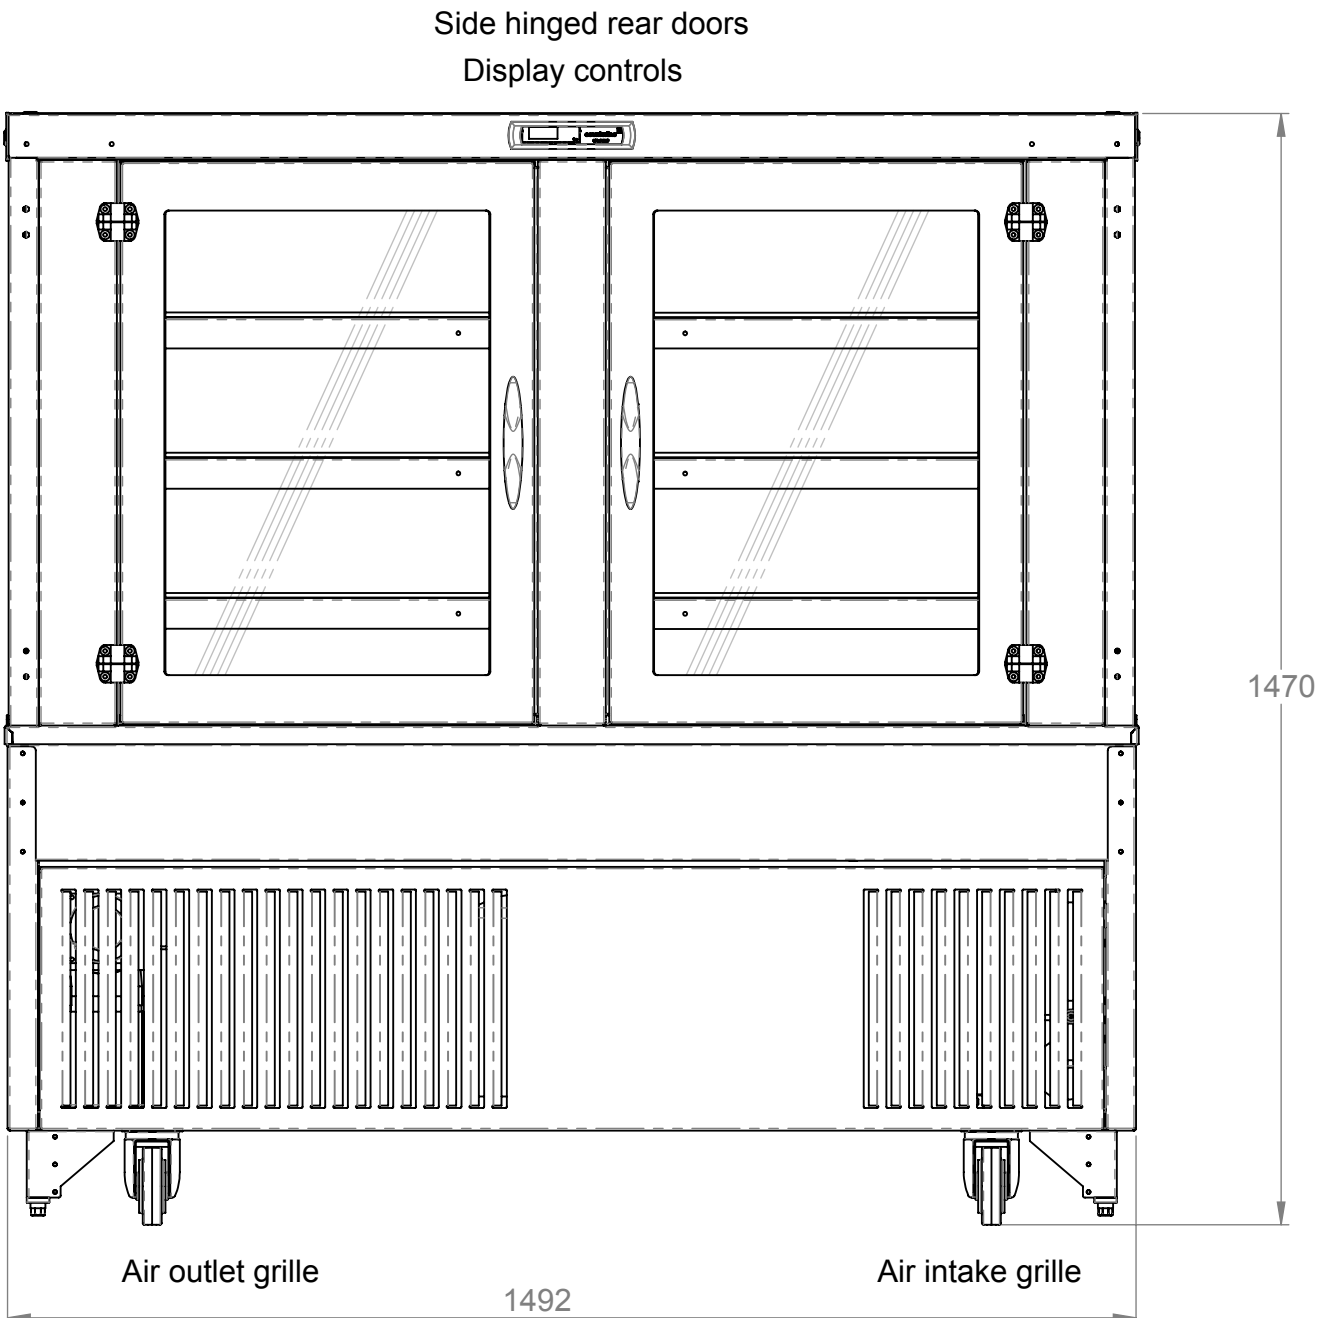

Rear elevation

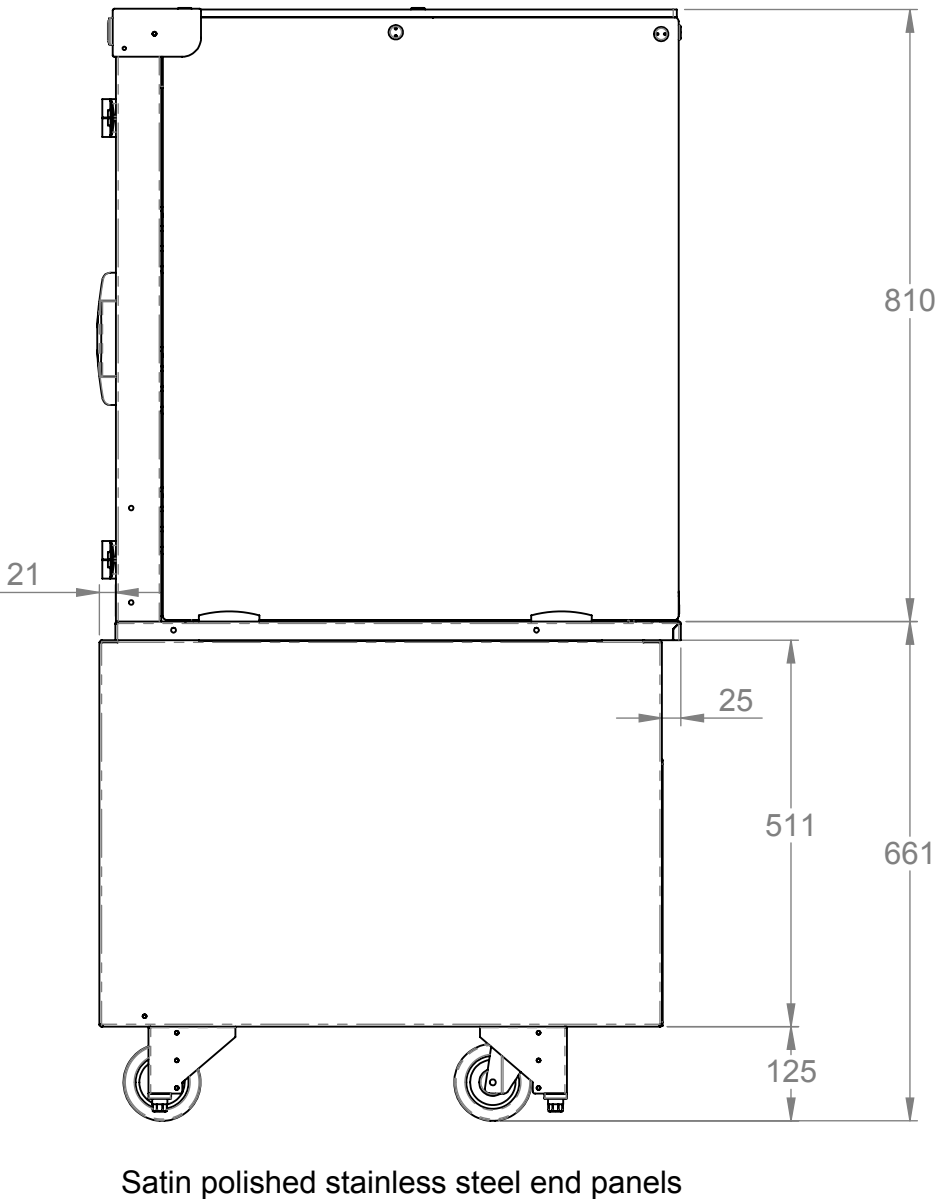

End elevation

Assembly No - SVC1500-GO

Electrical Spec - 13A, 230V, 2.8Kw,
via 13 Amp plugtop on 2.5 Metre lead

Weight - 290Kg Approx

Issue	Date	Description
counterline Randles Rd, Knowsley Business Park, Merseyside L34 9HZ. Tel: 0151 548 2211 Fax: 0151 549 2179		
Title: SQ Vision Enclosed Chilled 1500 Lg Display		
Drg No :		Issue: Date: 16/10/2015
15-773--A		Scale: 1:10 @ A2
Drn by: G Burgess		Chk'd: Date:
All dims in MM		