




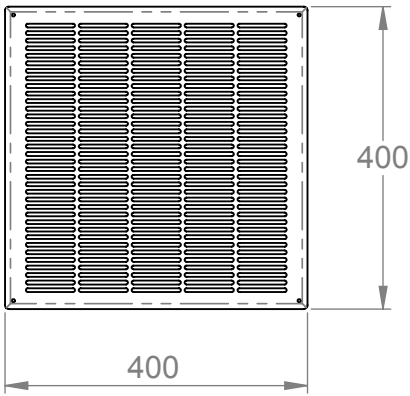


Stainless steel air inlet-outlet grille details

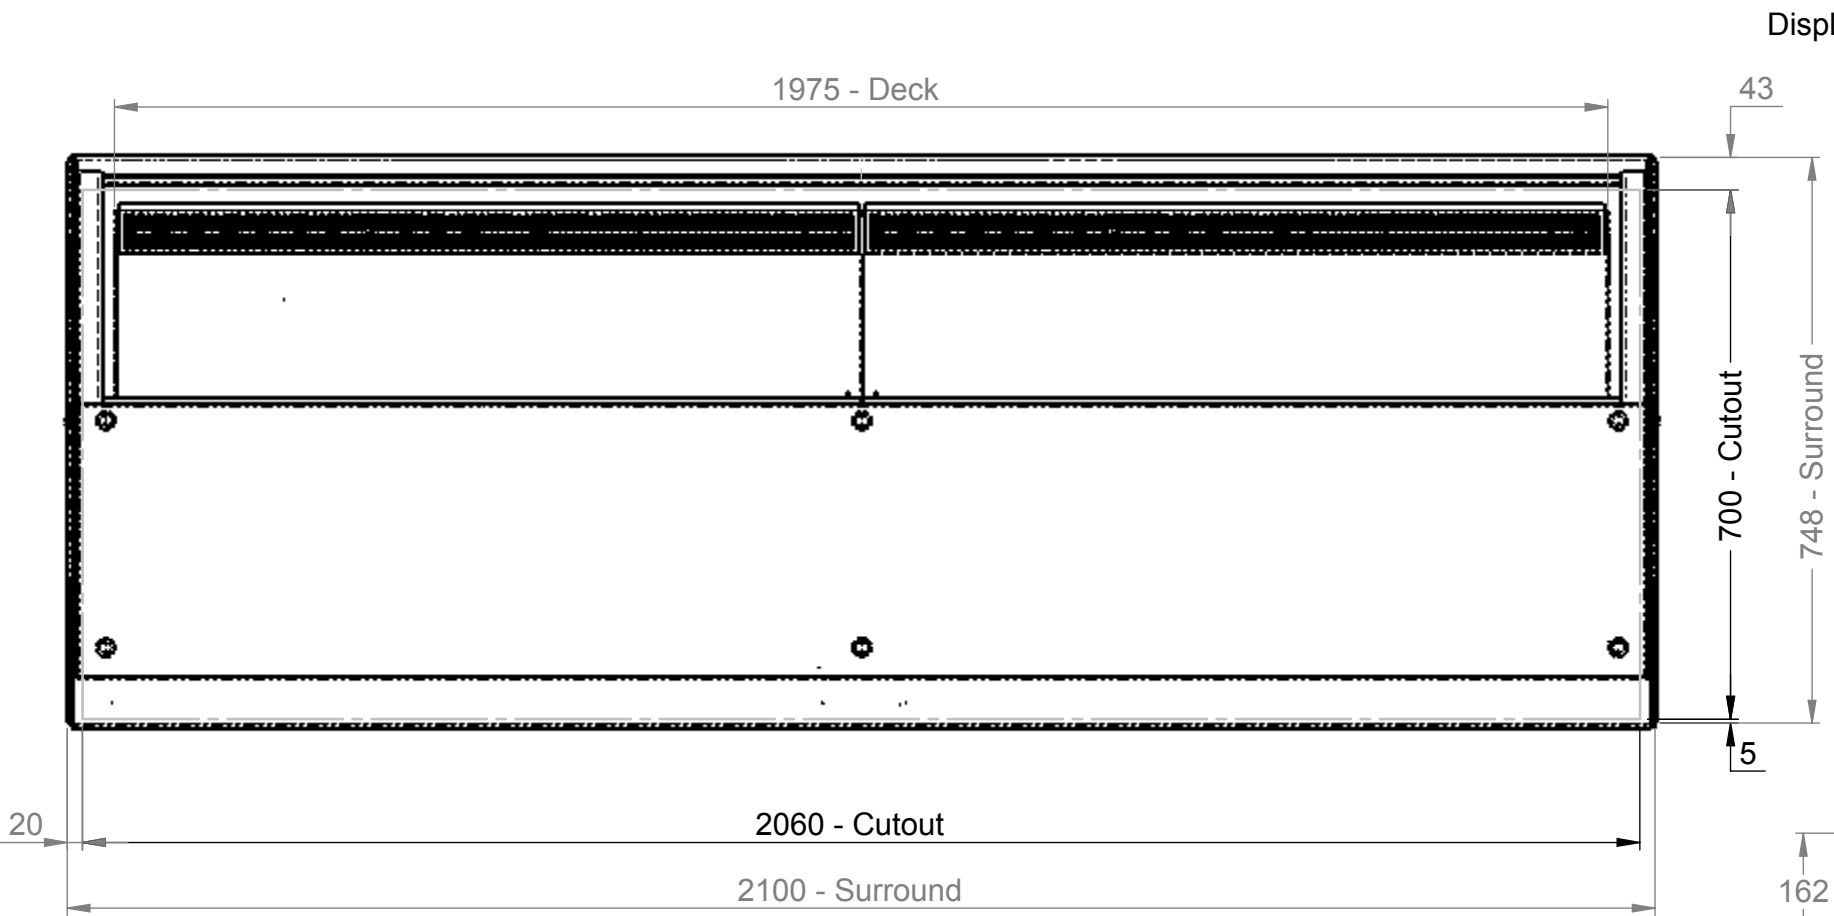


Plan

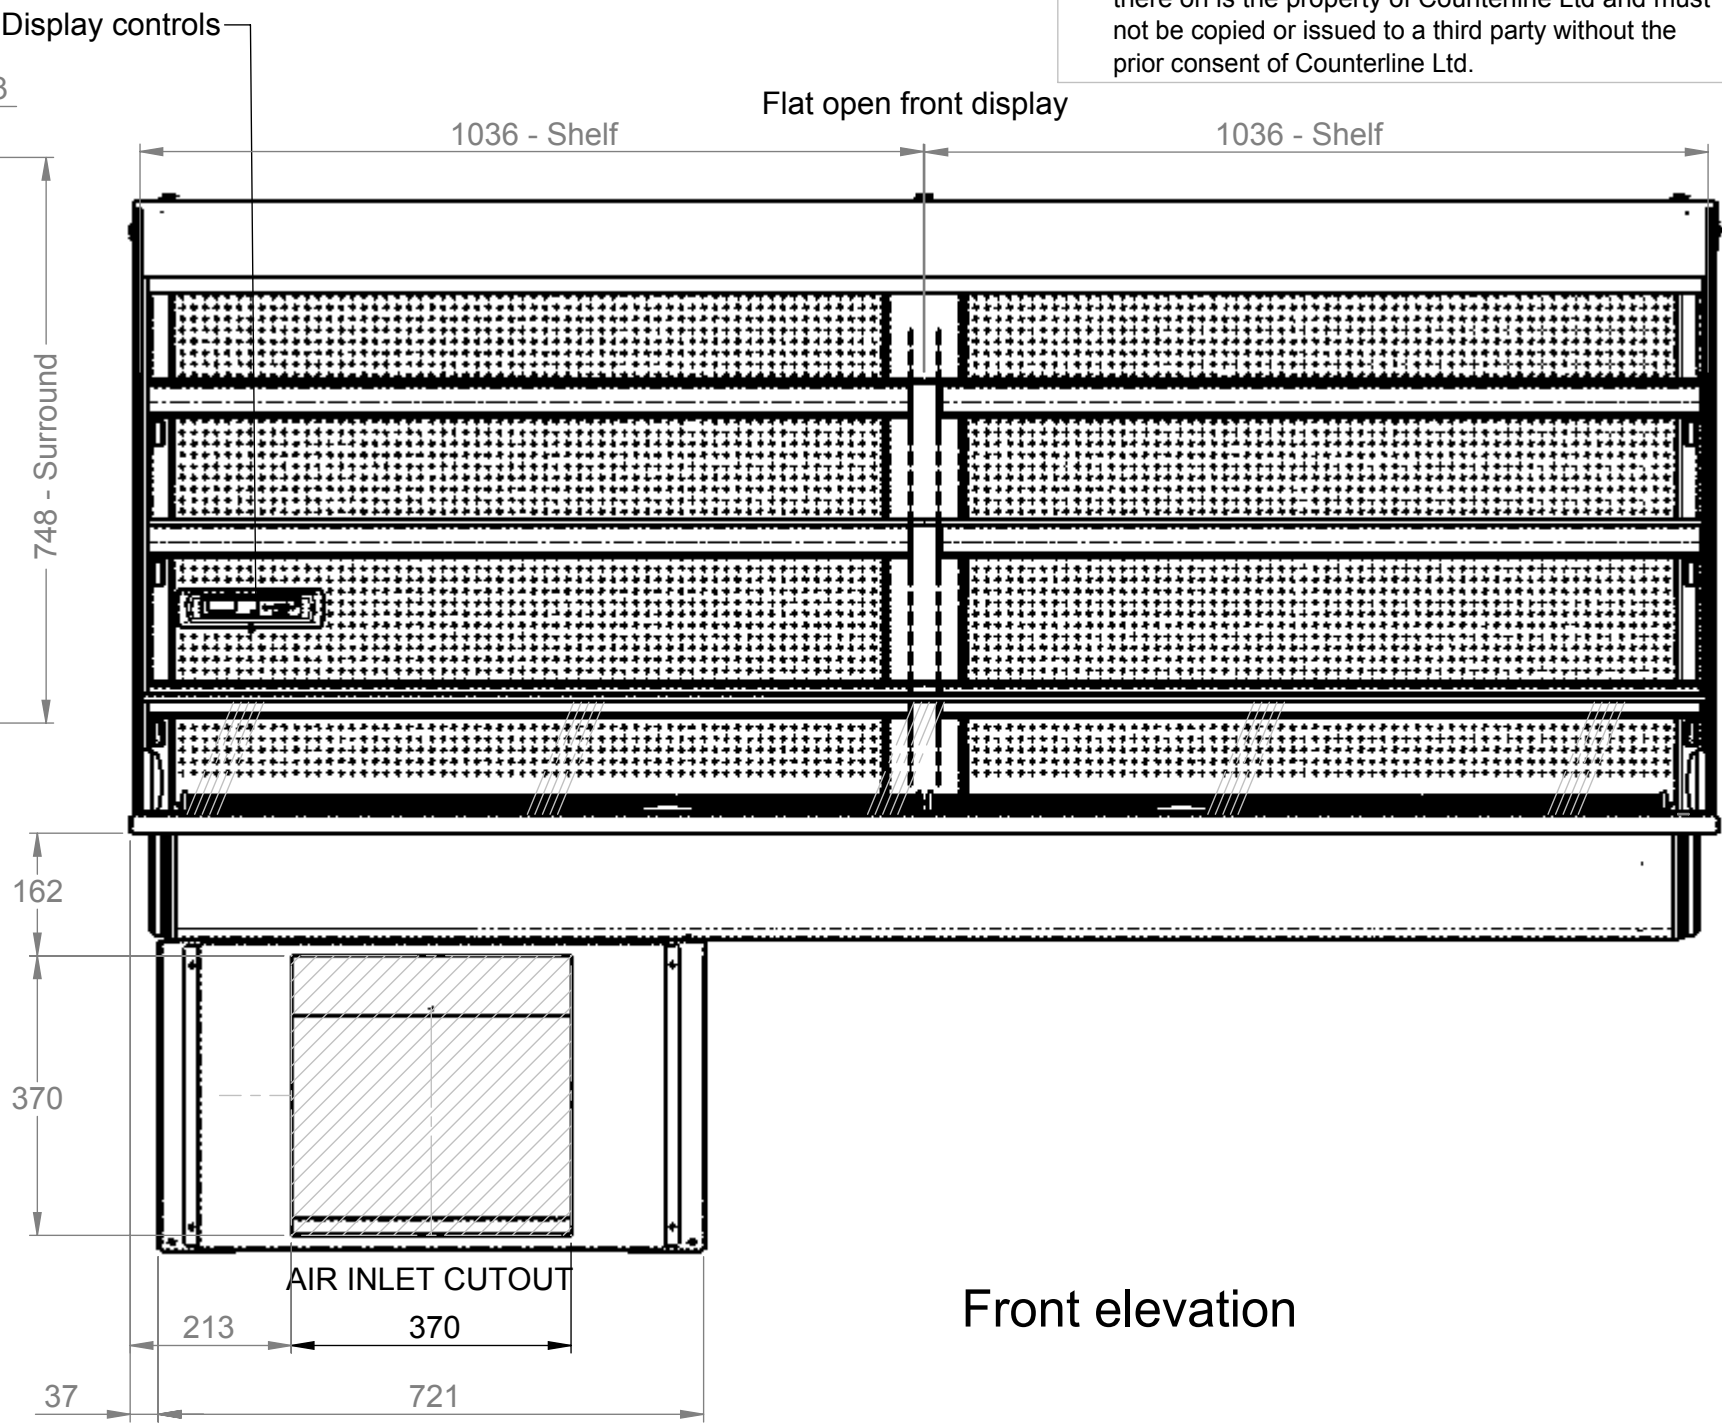


Front elevation

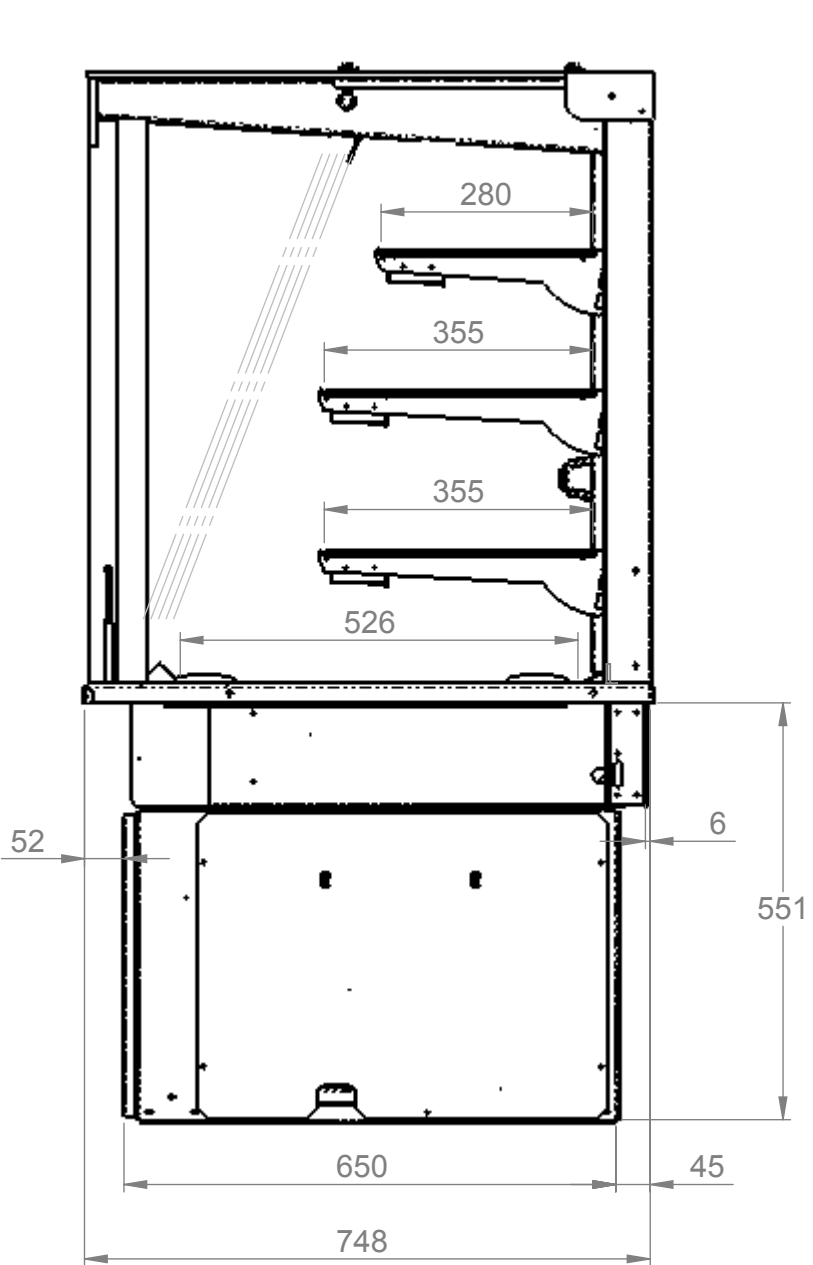

End elevation

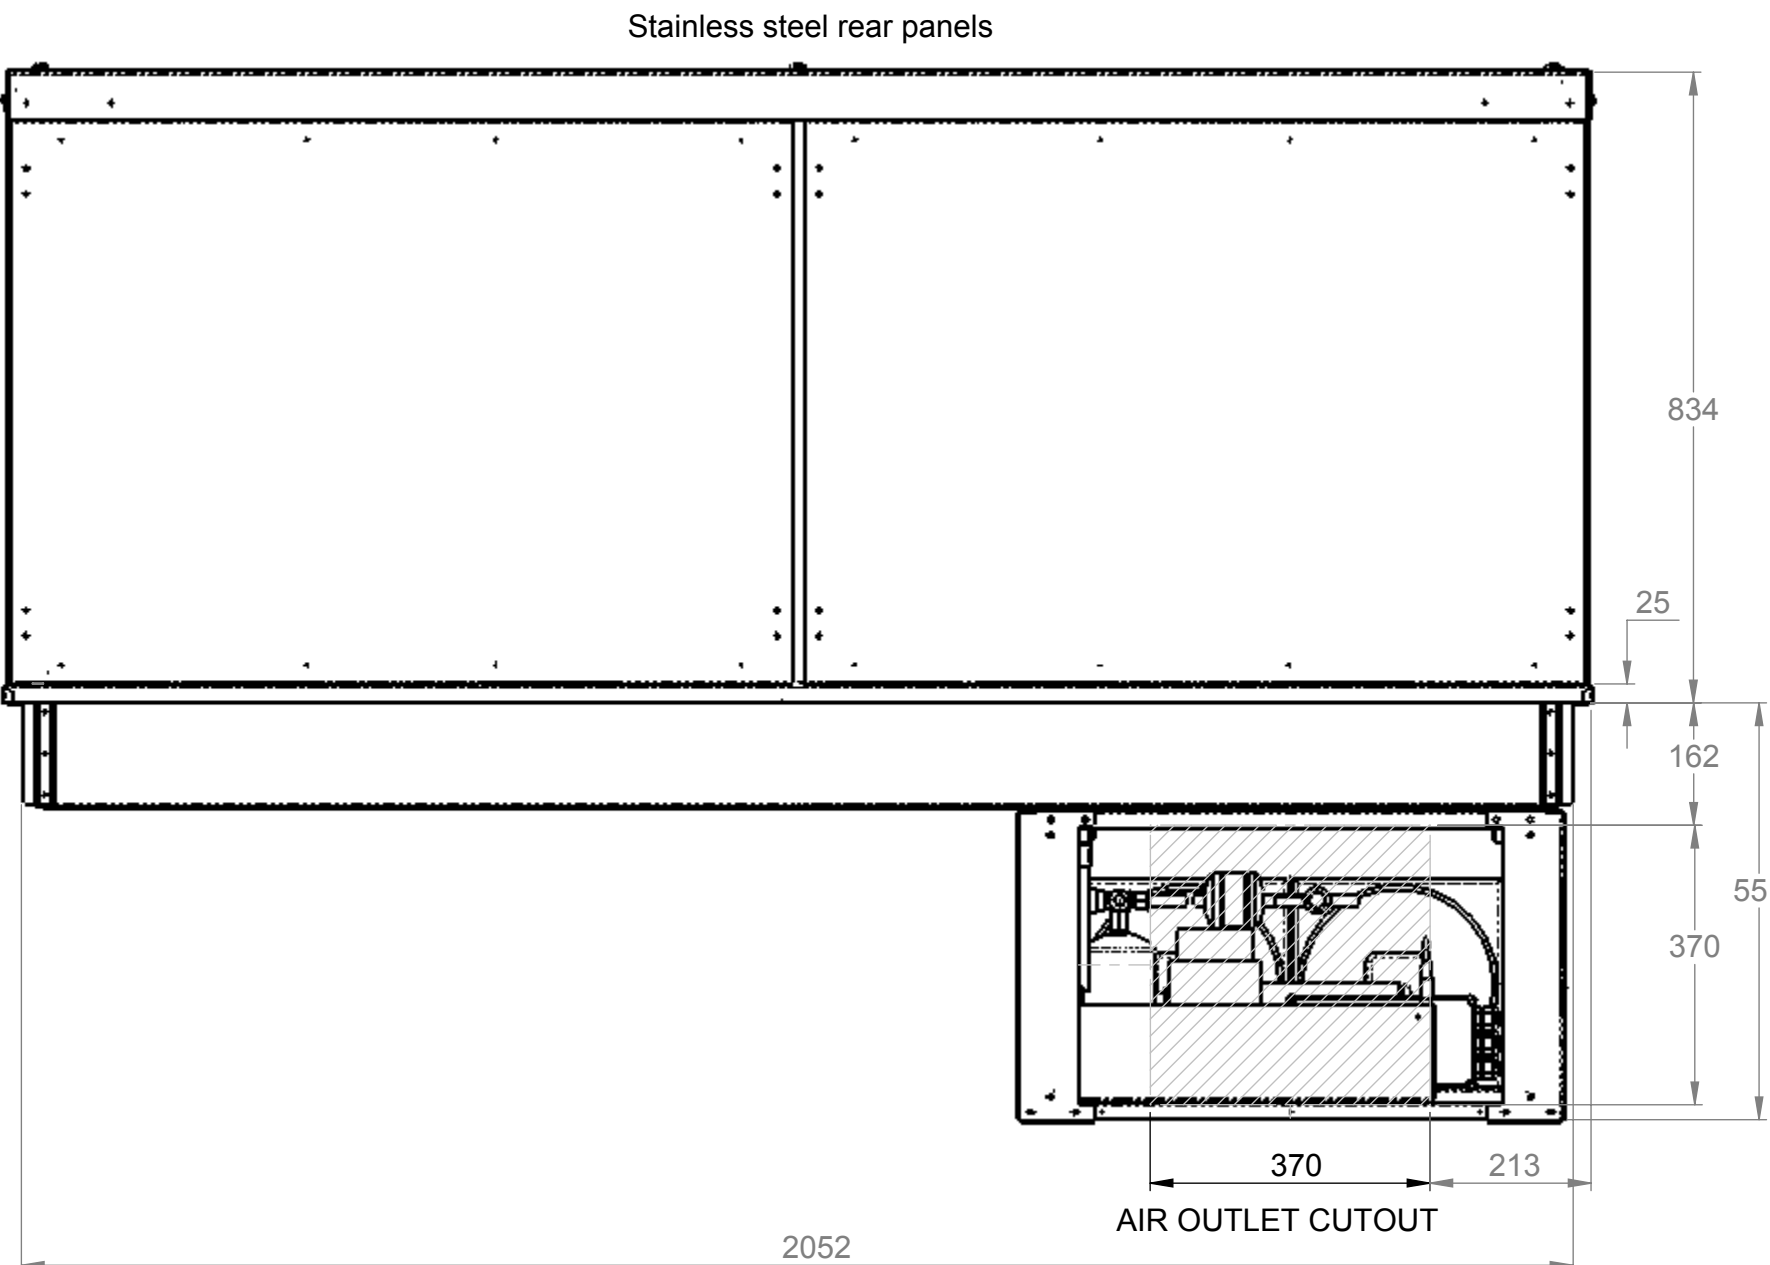

Rear elevation

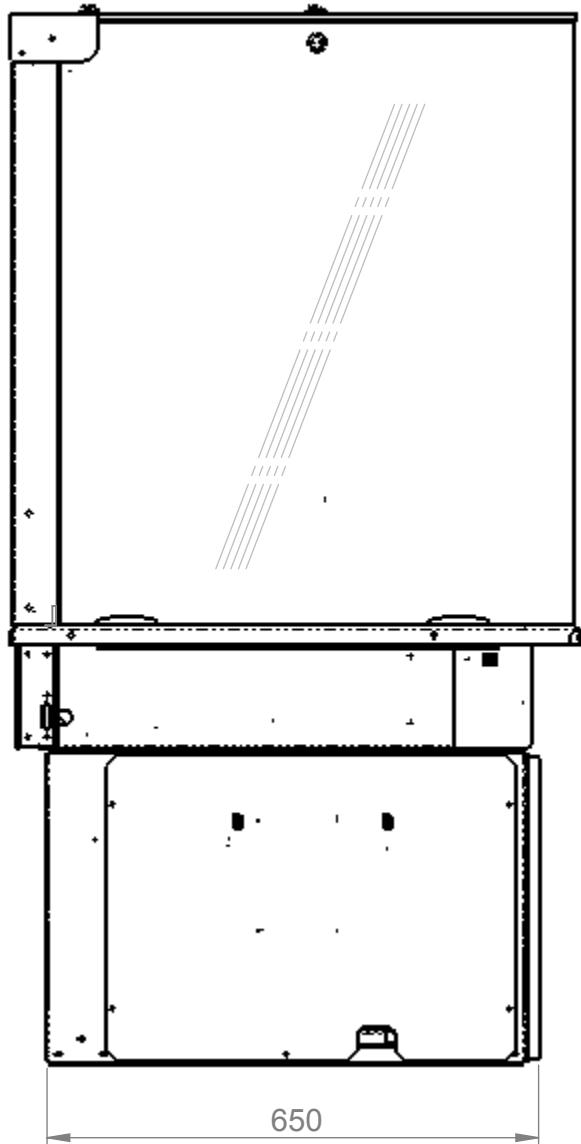

End elevation

Electrical Spec - 13A, 230V, 2.8Kw
via 13A plug top on 2.5 Metre lead
Weight - 350Kg Approx

Assembly No - SVOCDI2100-GC

3rd Angle Projection.
This drawing and the information properties contained there on is the property of Counterline Ltd and must not be copied or issued to a third party without the prior consent of Counterline Ltd.

Issue	Date	Description
counterline Randles Rd, Knowsley Business Park, Merseyside L34 9HZ. Tel: 0151 548 2211 Fax: 0151 549 2179		
Title: Vision SQ Self Help Chilled Display 2100 Long FB		
Drg No :	Issue:	Date: 15/10/2015
15-468--A		Scale: 1:10 @ A2
Drn by: G Burgess		Chk'd:
All dims in MM		Date: