




Plan

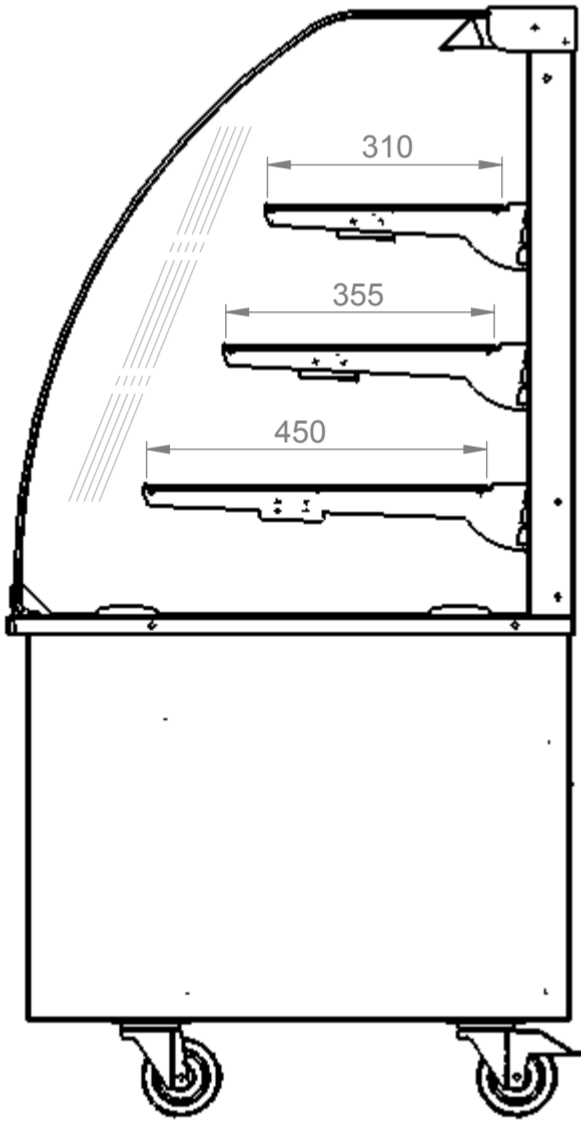


End elevation

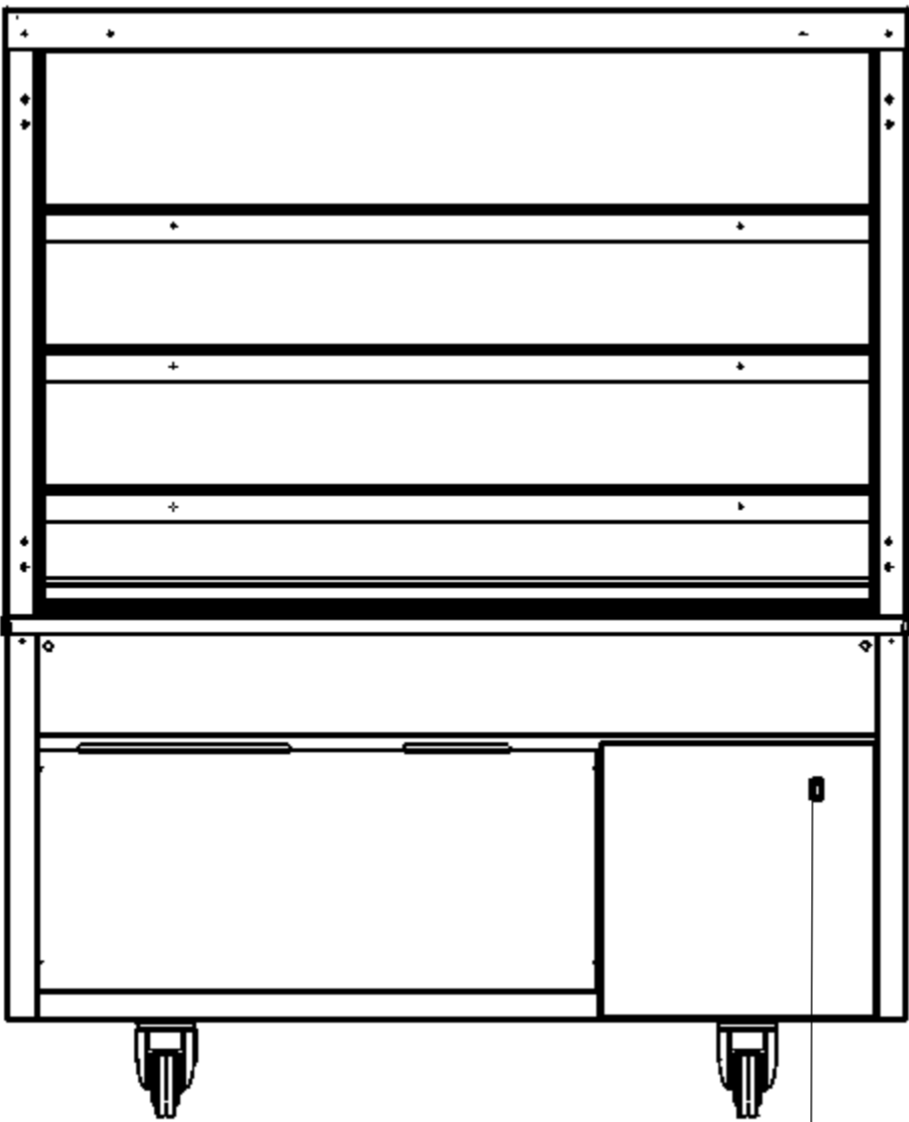

Rear elevation

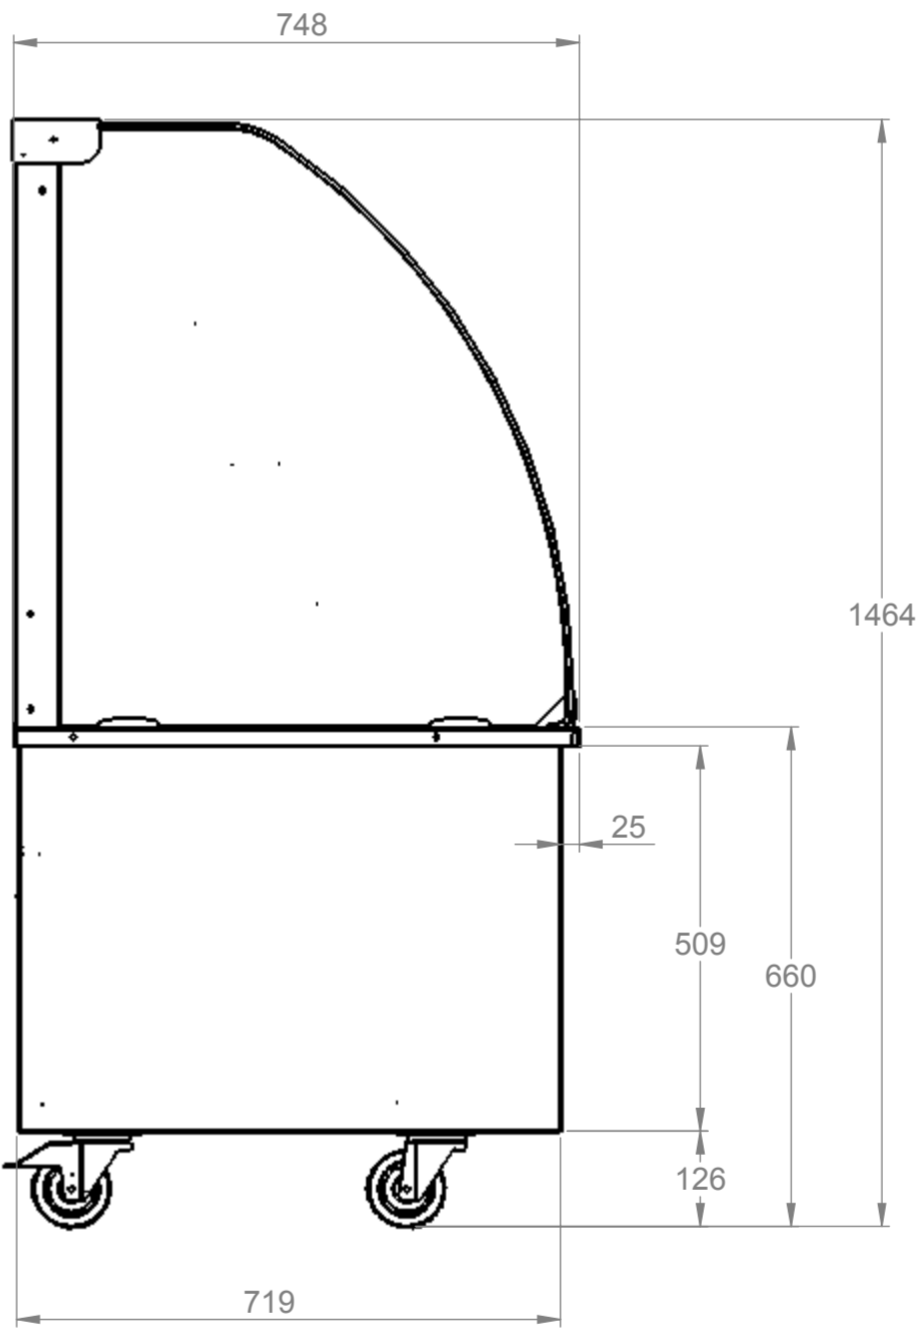


End elevation

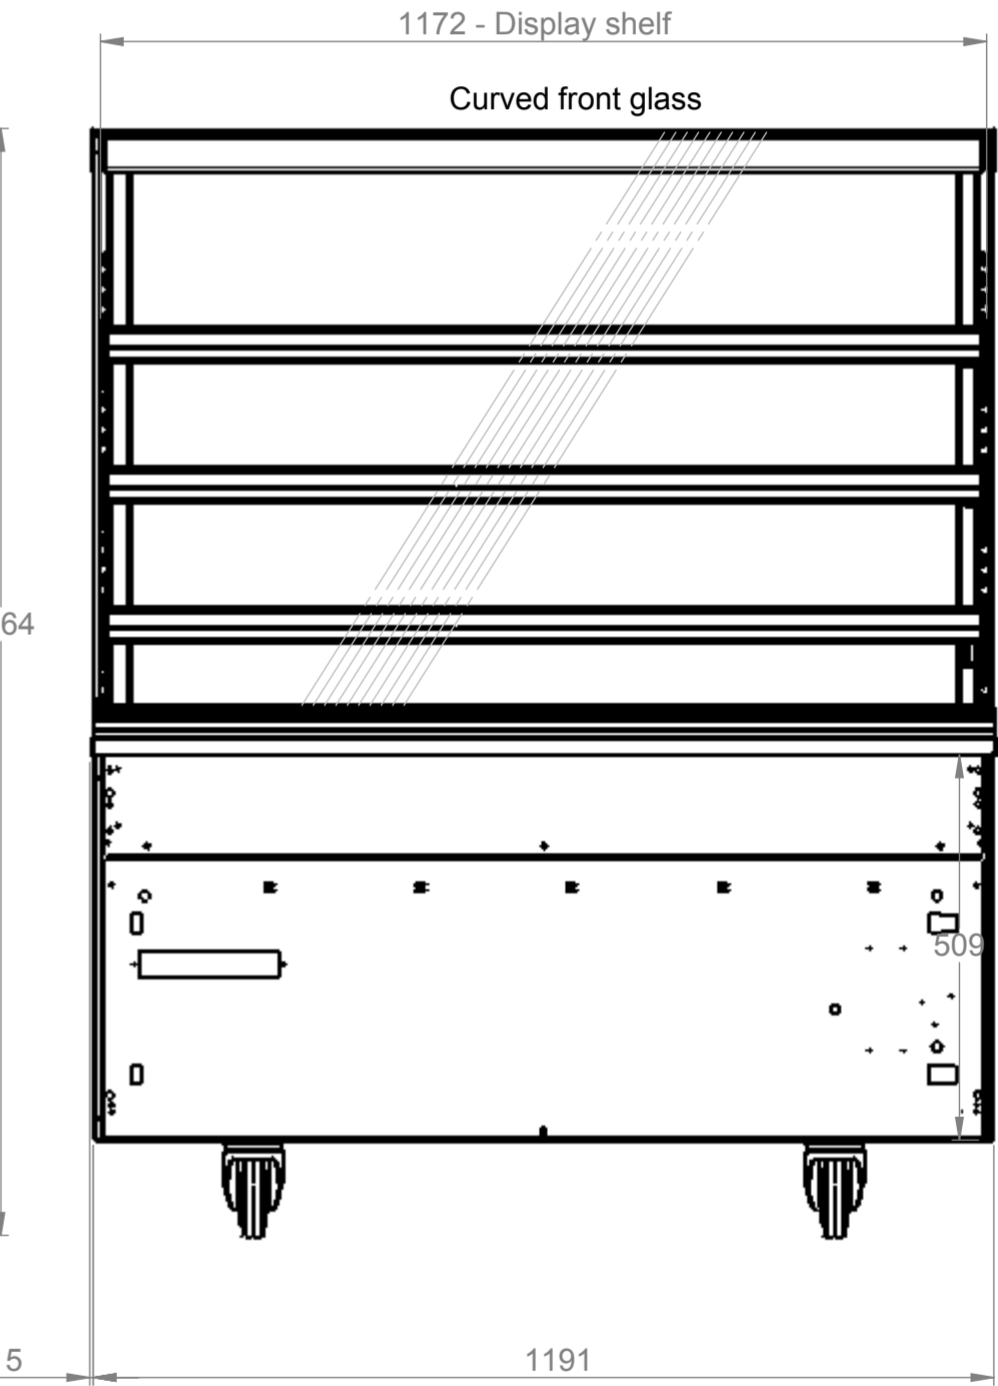

Front elevation

Electrical Spec - 13A, 230V, 0.3Kw  
via 13 Amp plugtop on 2.5 Metre lead  
Weight - 183Kg Approx

Assembly No - VA1200

Issue	Date	Description
<div>counterline</div> <div>Randles Rd, Knowsley Business Park, Merseyside L34 9HZ. Tel: 0151 548 2211 Fax: 0151 549 2179</div>		
Title: Vision Enclosed Ambient Display 1200		
Drg No :		Issue: Date: 13/01/2015
14-723--A		Scale: 1:10 @ A2
Drn by: G Burgess		Chk'd: Date:
All dims in MM		