




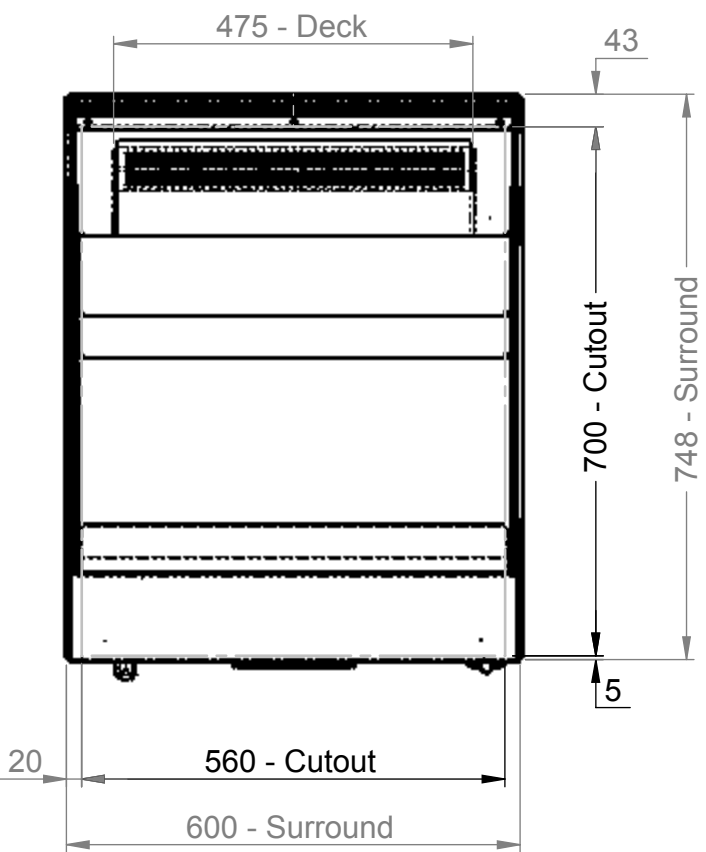


Plan

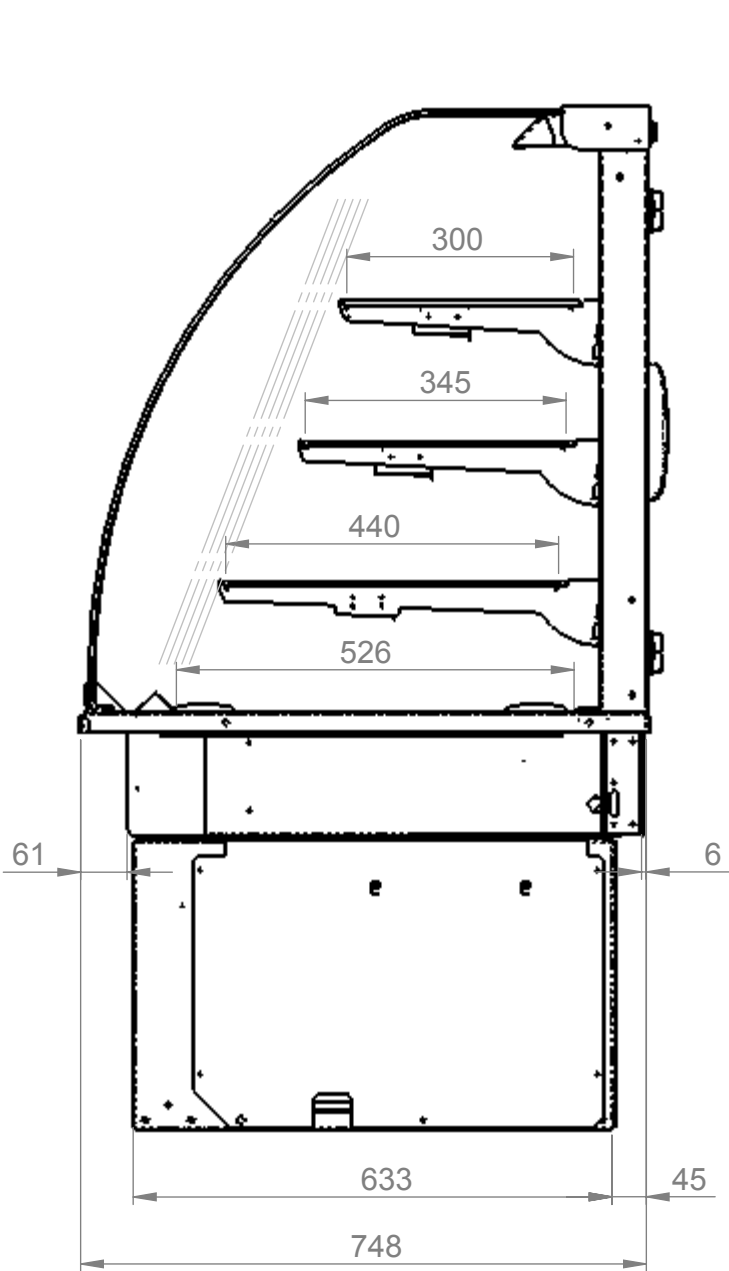


End elevation

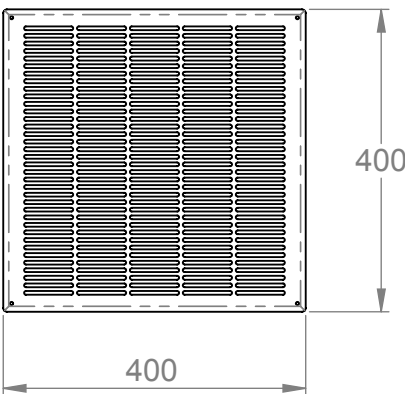


Stainless steel air inlet-outlet grille details

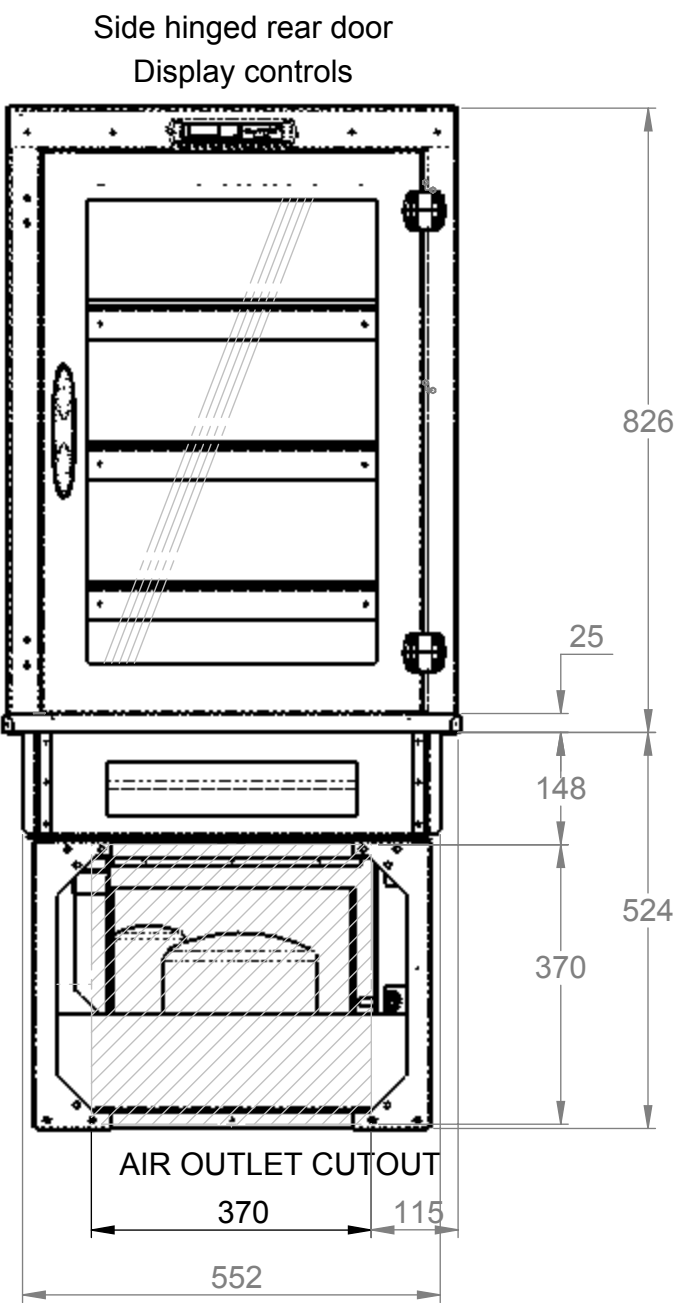

Rear elevation

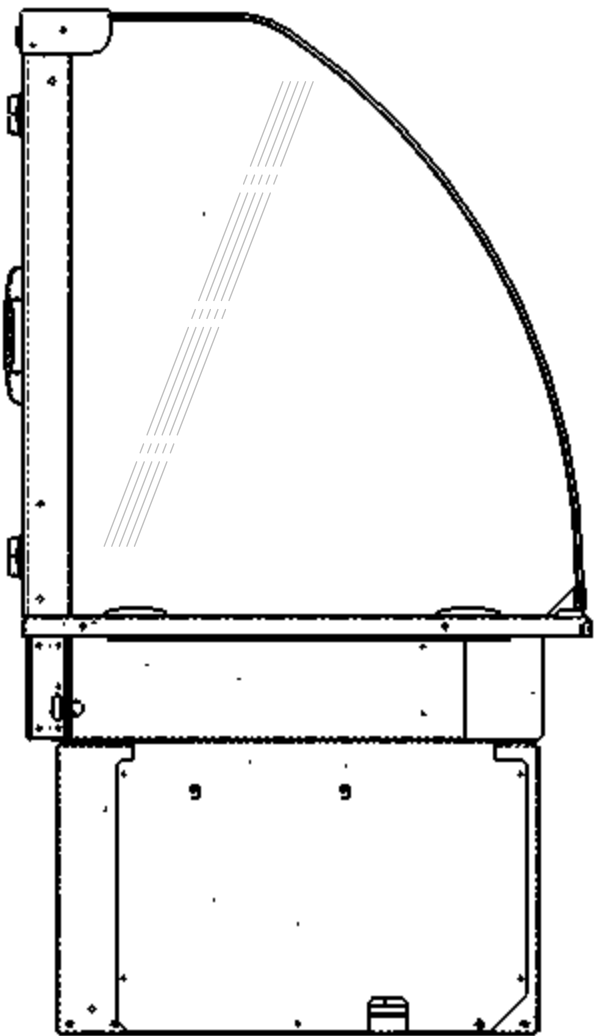

End elevation

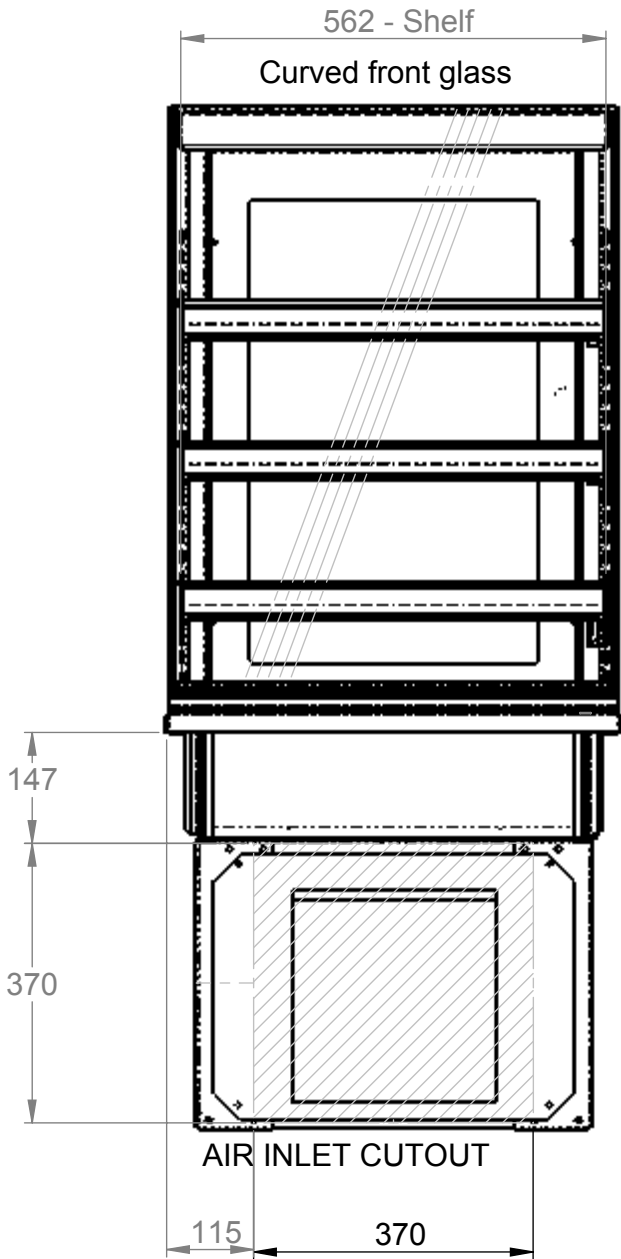

Front elevation

Electrical Spec - 13A, 230V, 1.8Kw
via 13A plug top on 2.5 Metre lead

Weight - 118Kg Approx

Assembly No - VCDI600-GO

Issue	Date	Description
counterline Randles Rd, Knowsley Business Park, Merseyside L34 9HZ. Tel: 0151 548 2211 Fax: 0151 549 2179		
Title: Vision Enclosed Chilled Display 600		
Drg No :		Issue: Date: 12/01/2015
14-240--A		Scale: 1:10 @ A2
Chk'd:		Date:
Drn by: G Burgess	All dims in MM	