




Plan

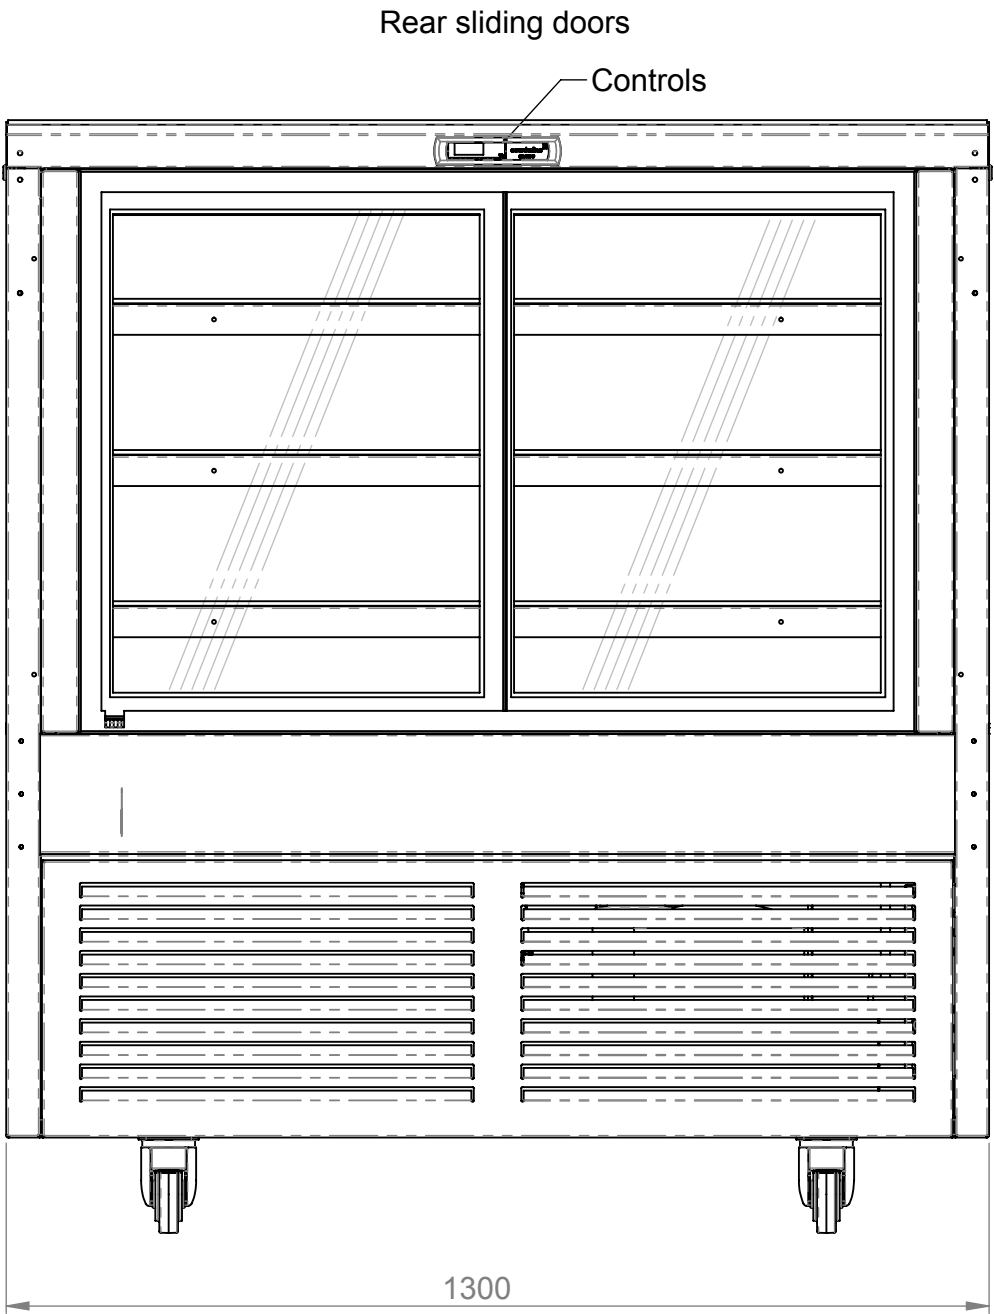


Rear elevation

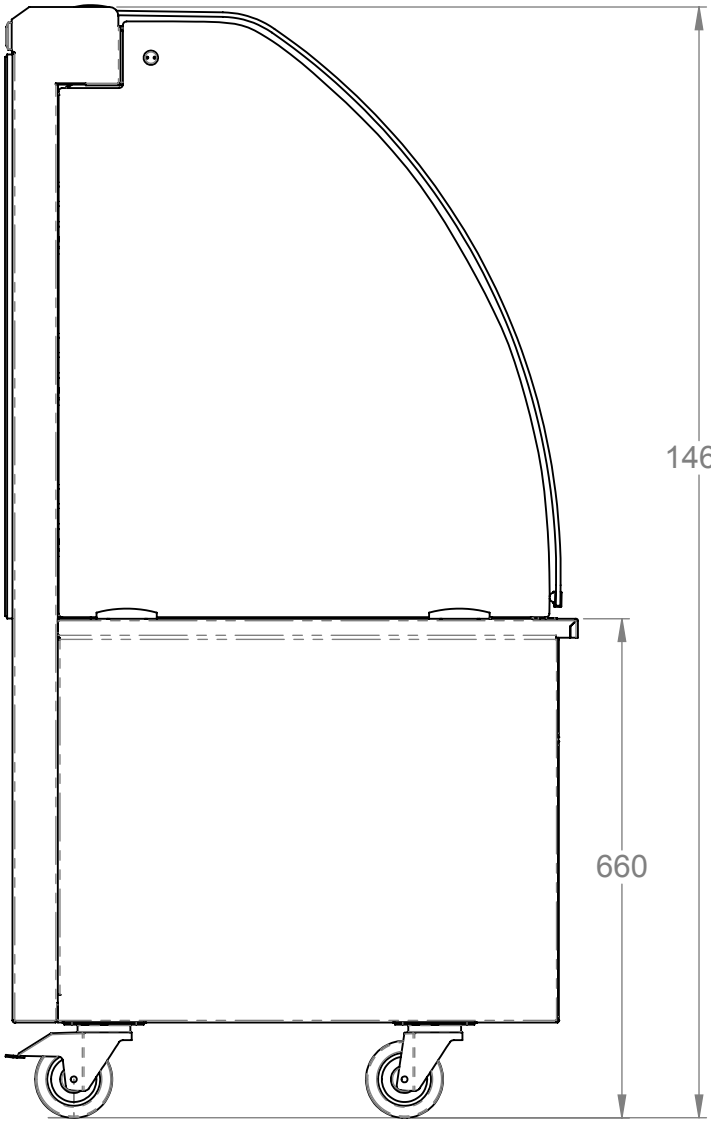

End elevation

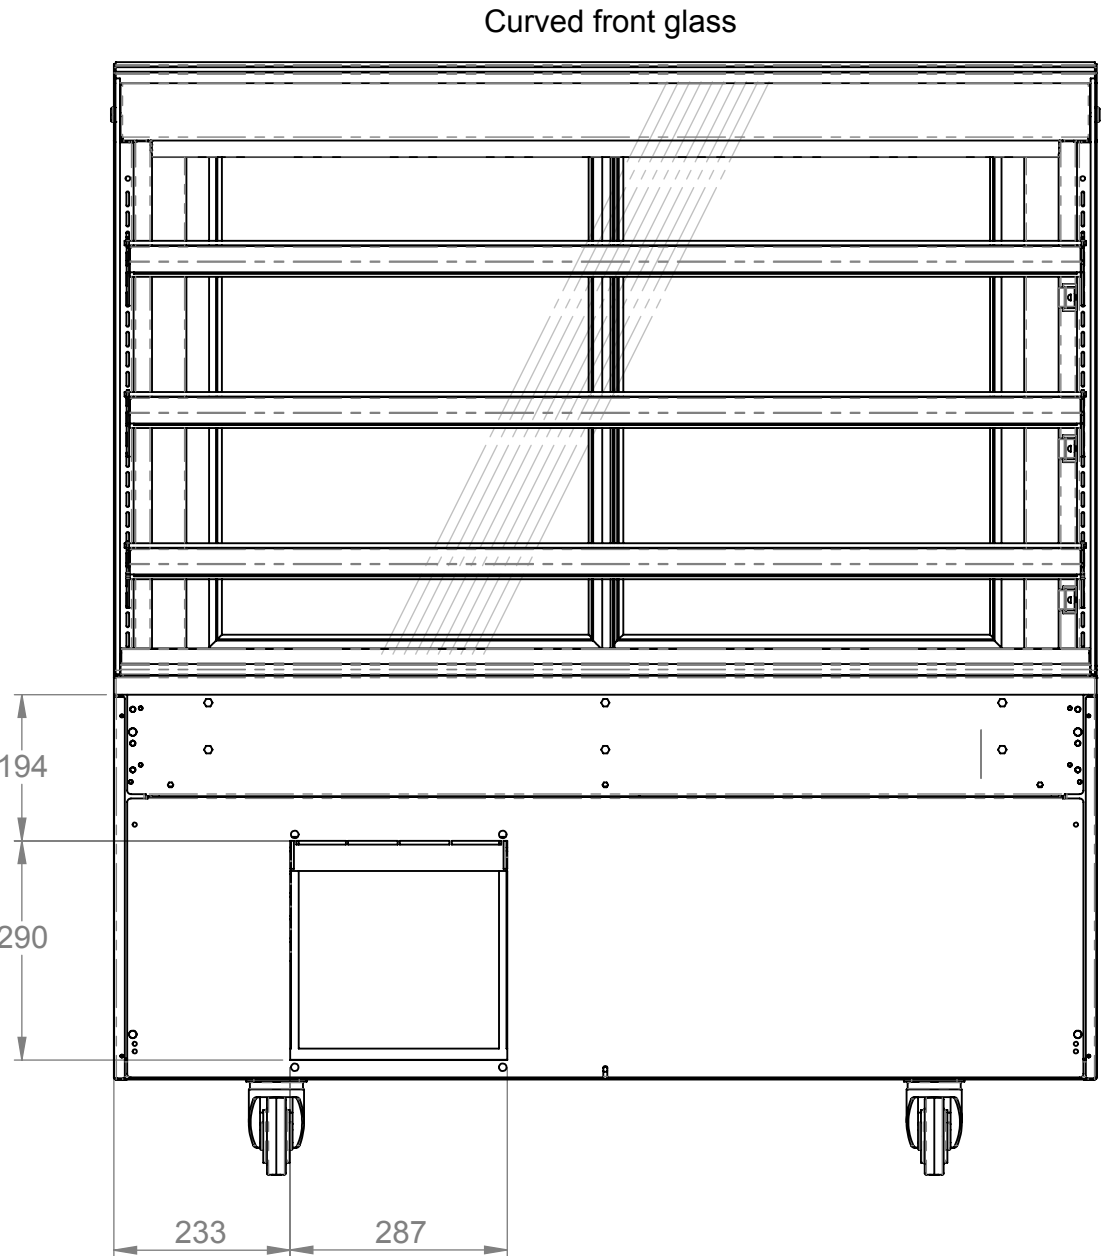


Front elevation

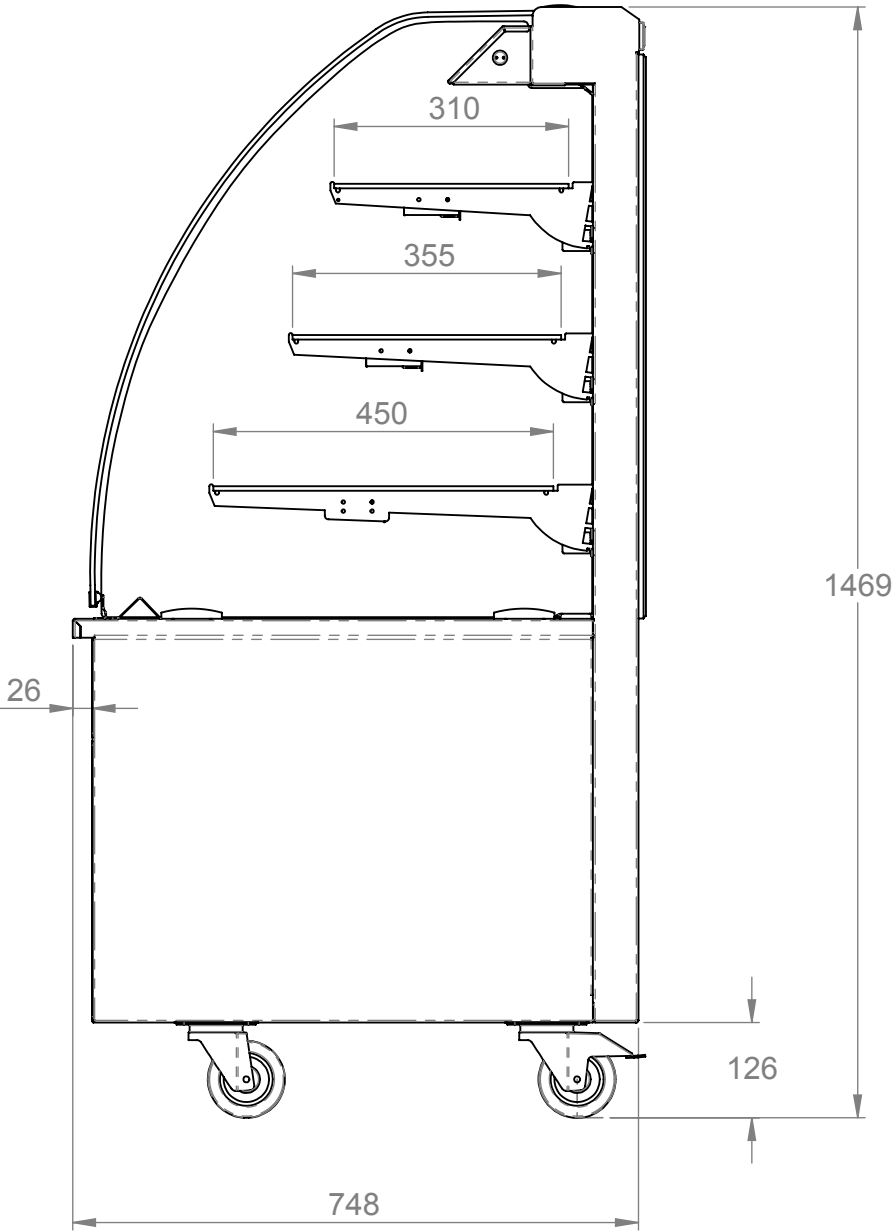

End elevation

Electrical Spec - 13A, 230V, 2.3Kw
via 13A plugtop on 2.5 Metre lead
Weight 252Kg Approx

Assembly No - VCL1300-GO

Issue	Date	Description
<div><p>Randles Rd, Knowsley Business Park, Merseyside L34 9HZ. Tel: 0151 548 2211 Fax: 0151 549 2179</p></div>		
Title: Vision Enclosed Chilled 1300 (Lift up Glass)		
Drg No :		Issue: Date: 02/09/2014
13-227--A		Scale: 1:10 @ A2
Drn by: G Burgess		Chk'd: Date: