




Plan

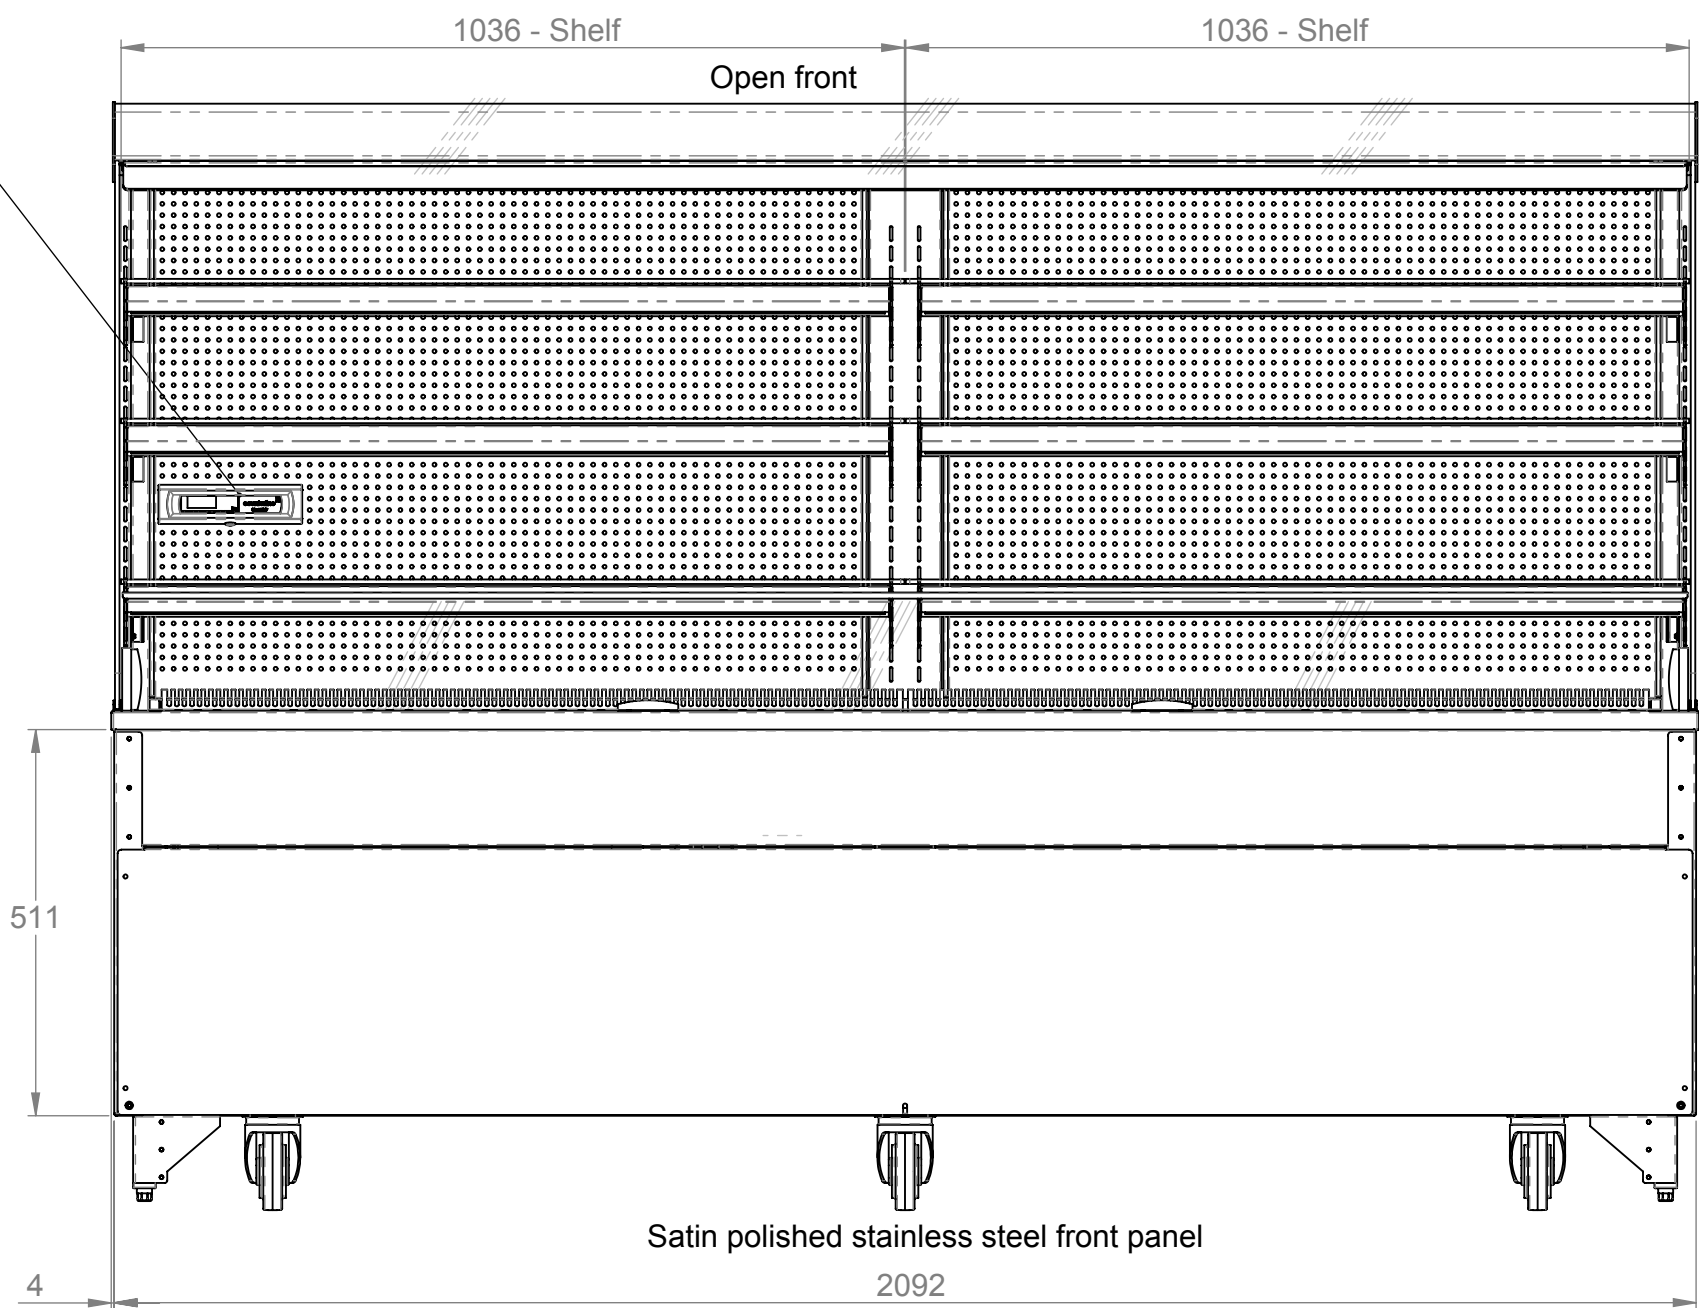


Front elevation

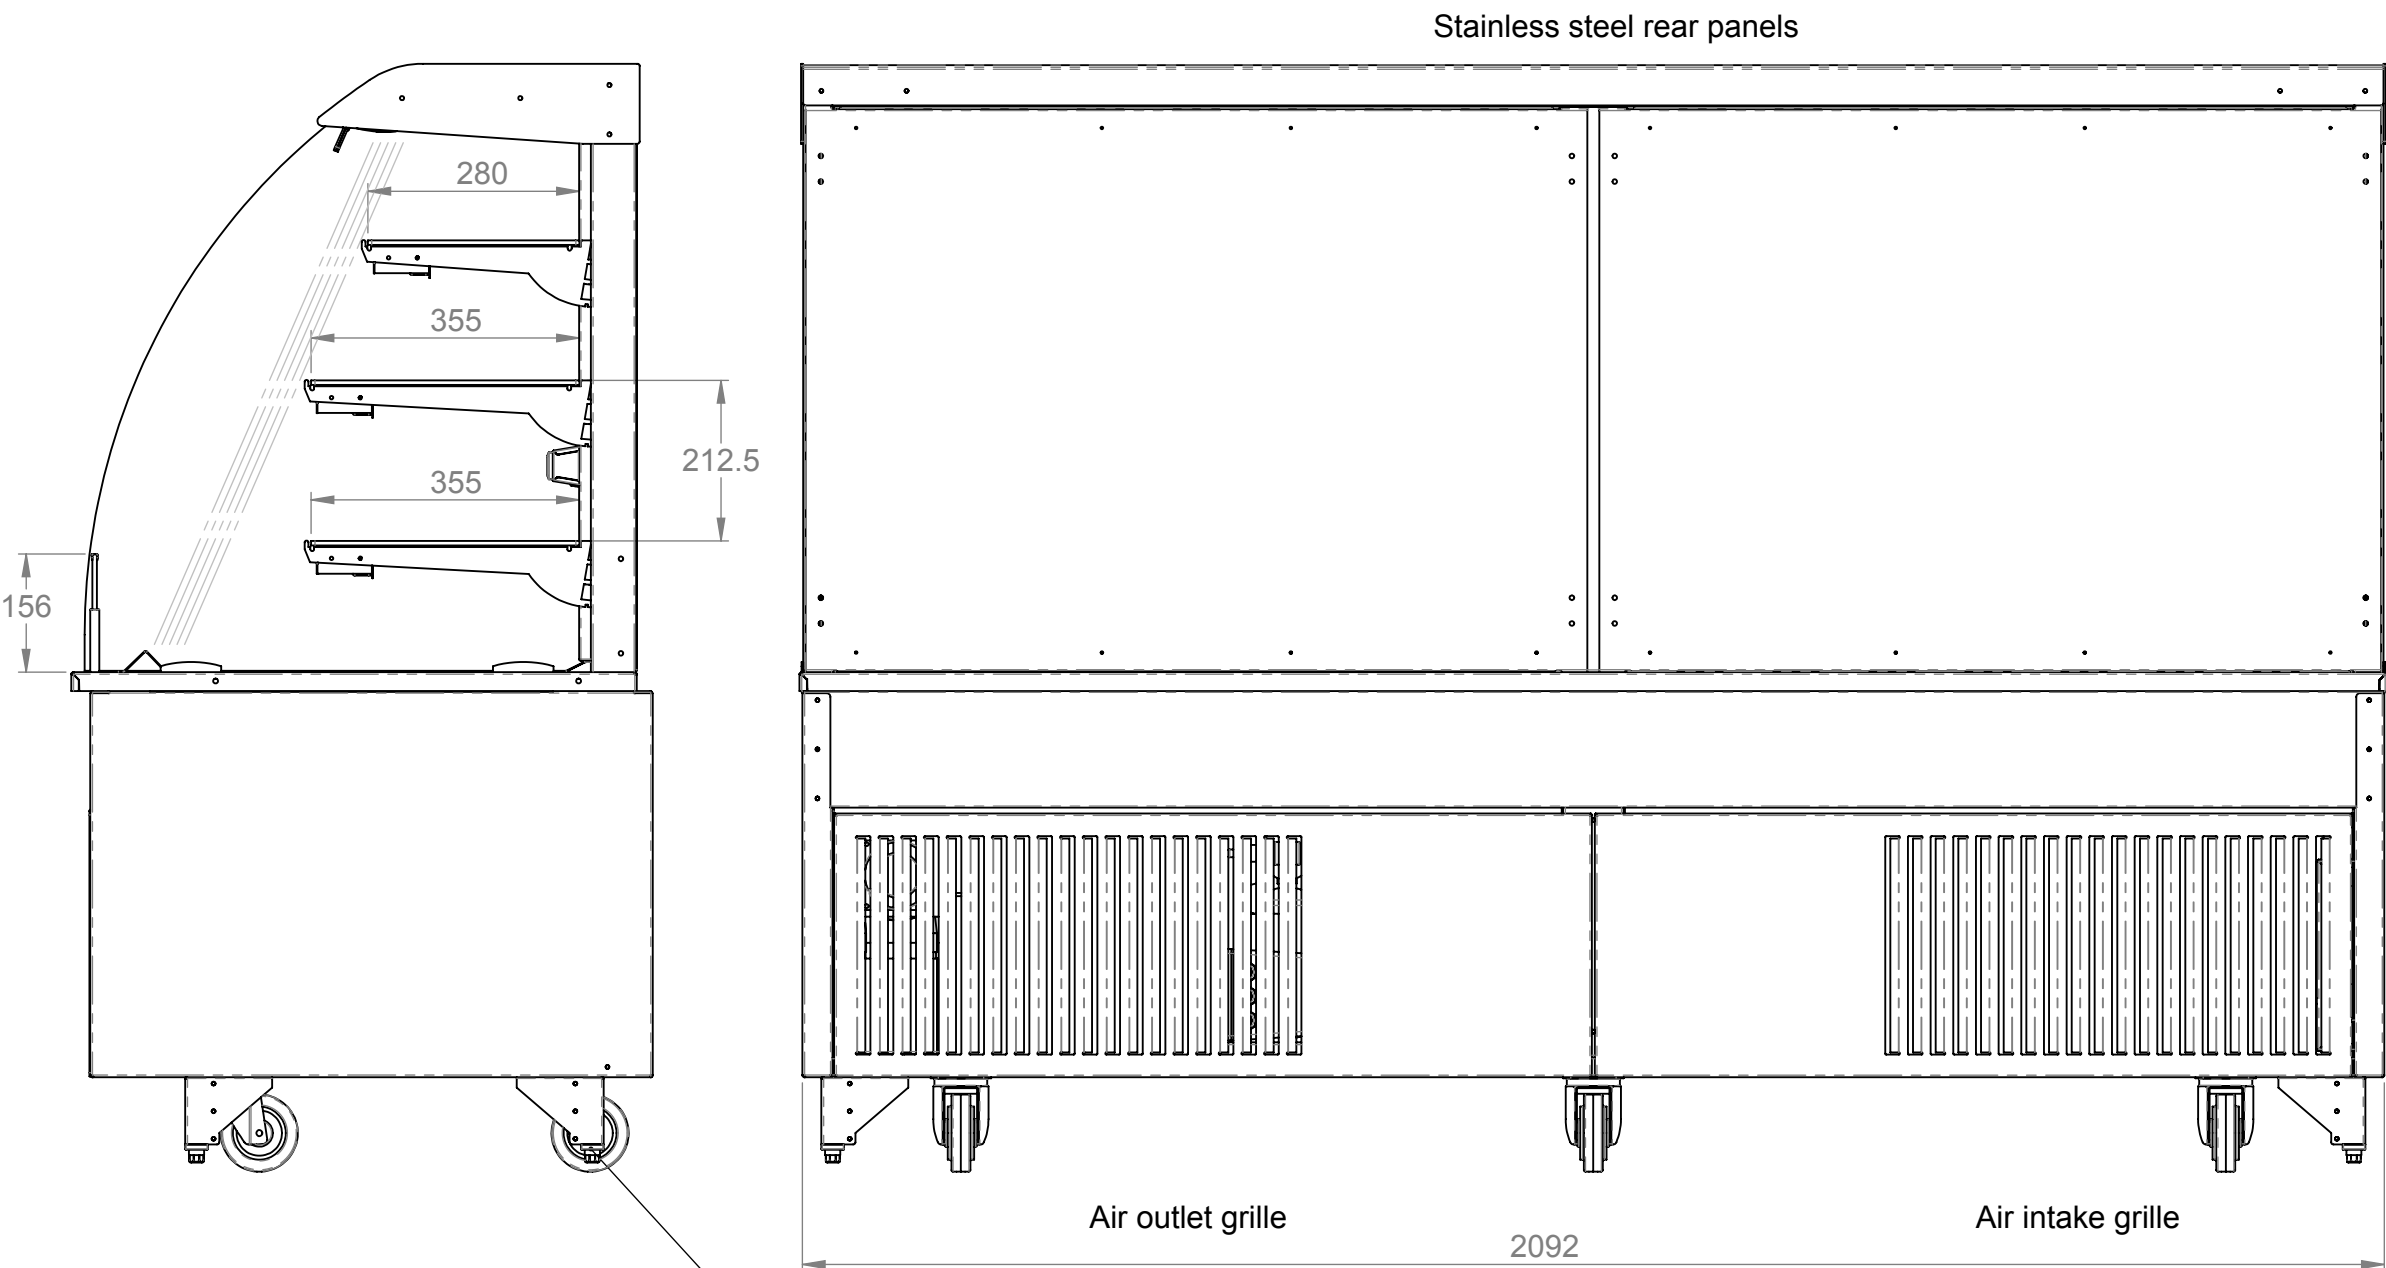

Rear elevation

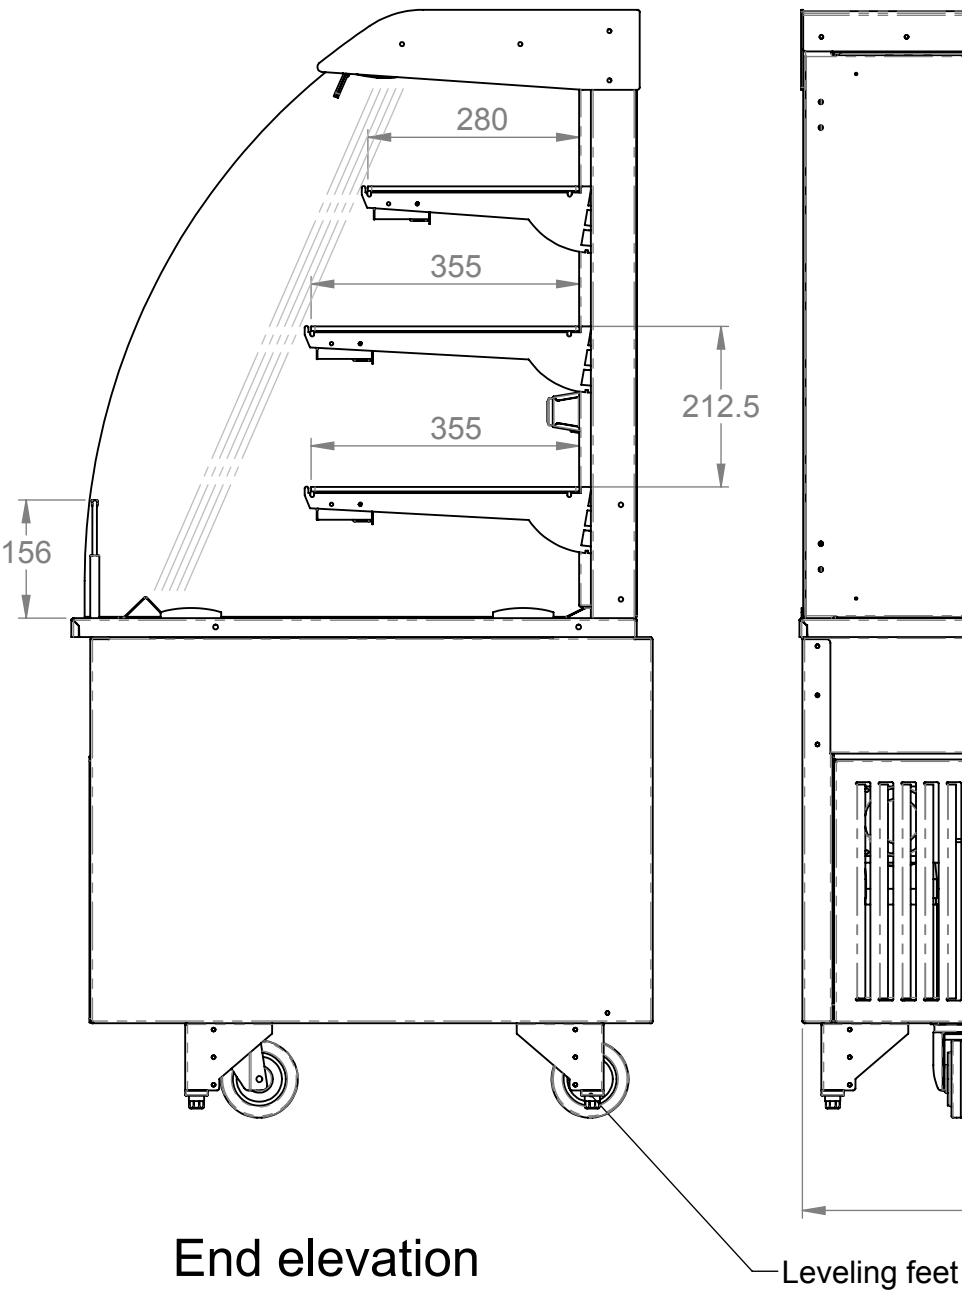

End elevation

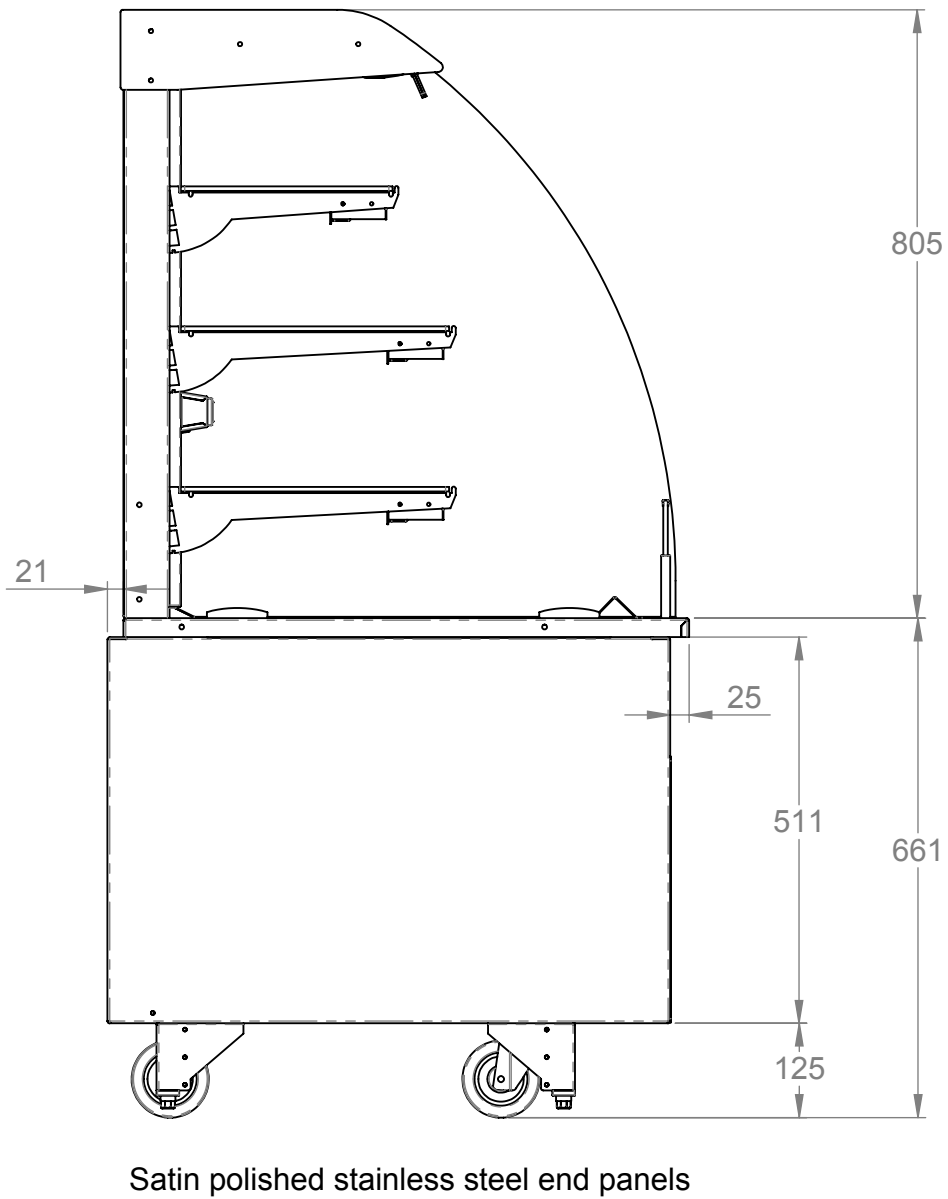

End elevation

Assembly No - VOC2100-GC

Electrical Spec - 13A, 230V, 2.8Kw,  
via 13 Amp plugtop on 2.5 Metre lead

Weight - 290Kg Approx

Issue	Date	Description
<div>counterline</div> <div>Randles Rd, Knowsley Business Park, Merseyside L34 9HZ. Tel: 0151 548 2211 Fax: 0151 549 2179</div>		
Title: Vision Open Chilled 2100 Lg Display FB		
Drg No :		Issue: Date: 12/11/2015
15-786--A		Scale: 1:10 @ A2
Drn by: G Burgess		Chk'd: Date:
All dims in MM		