




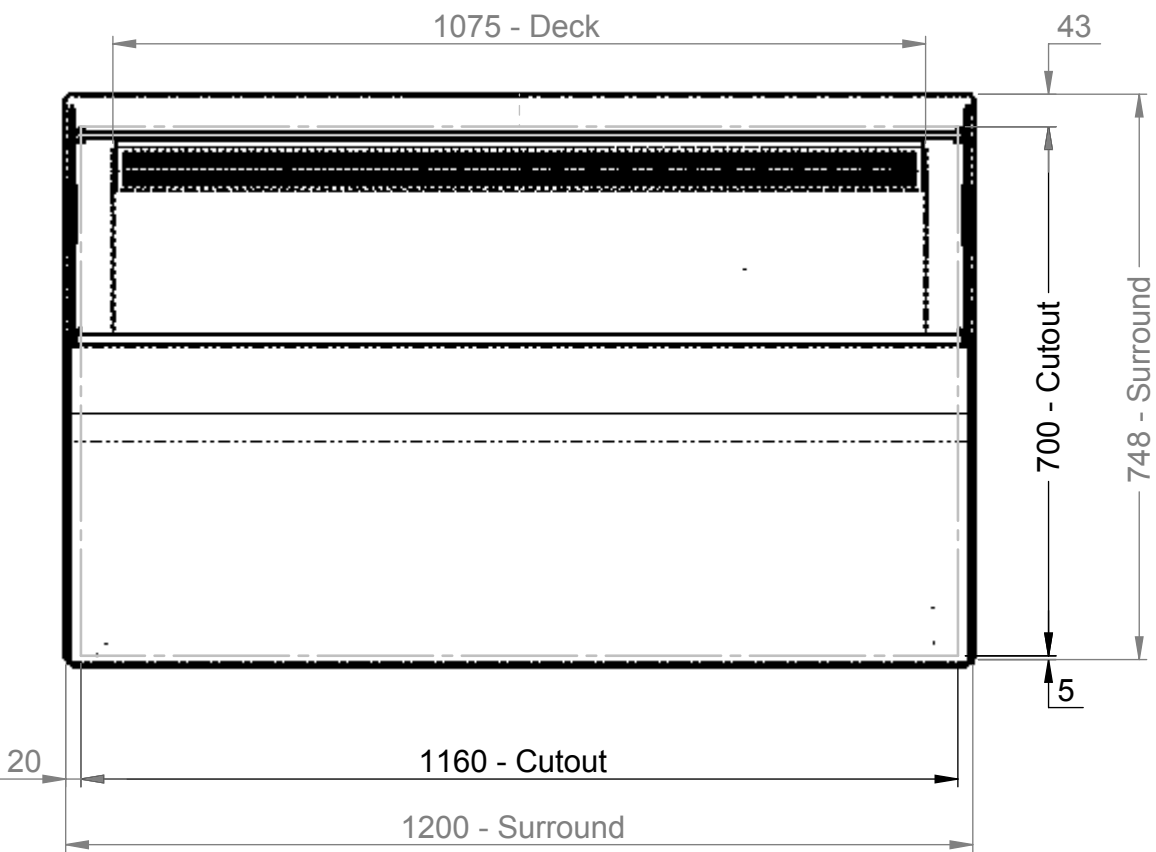


Plan

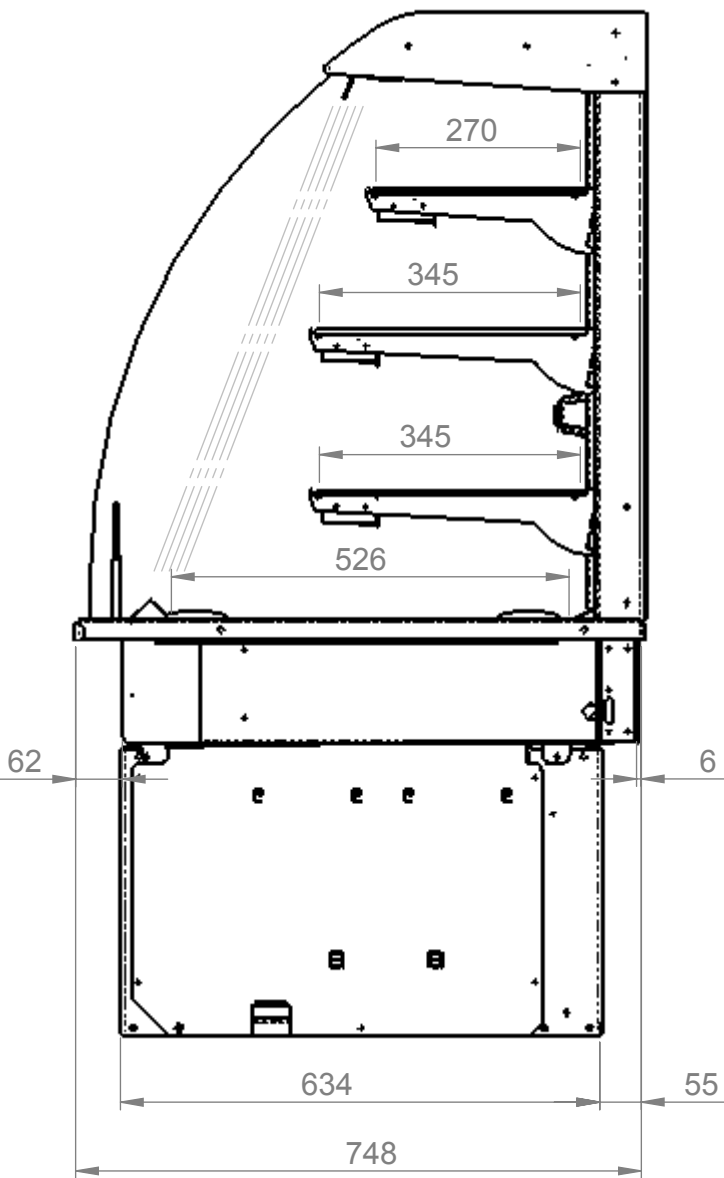


End elevation

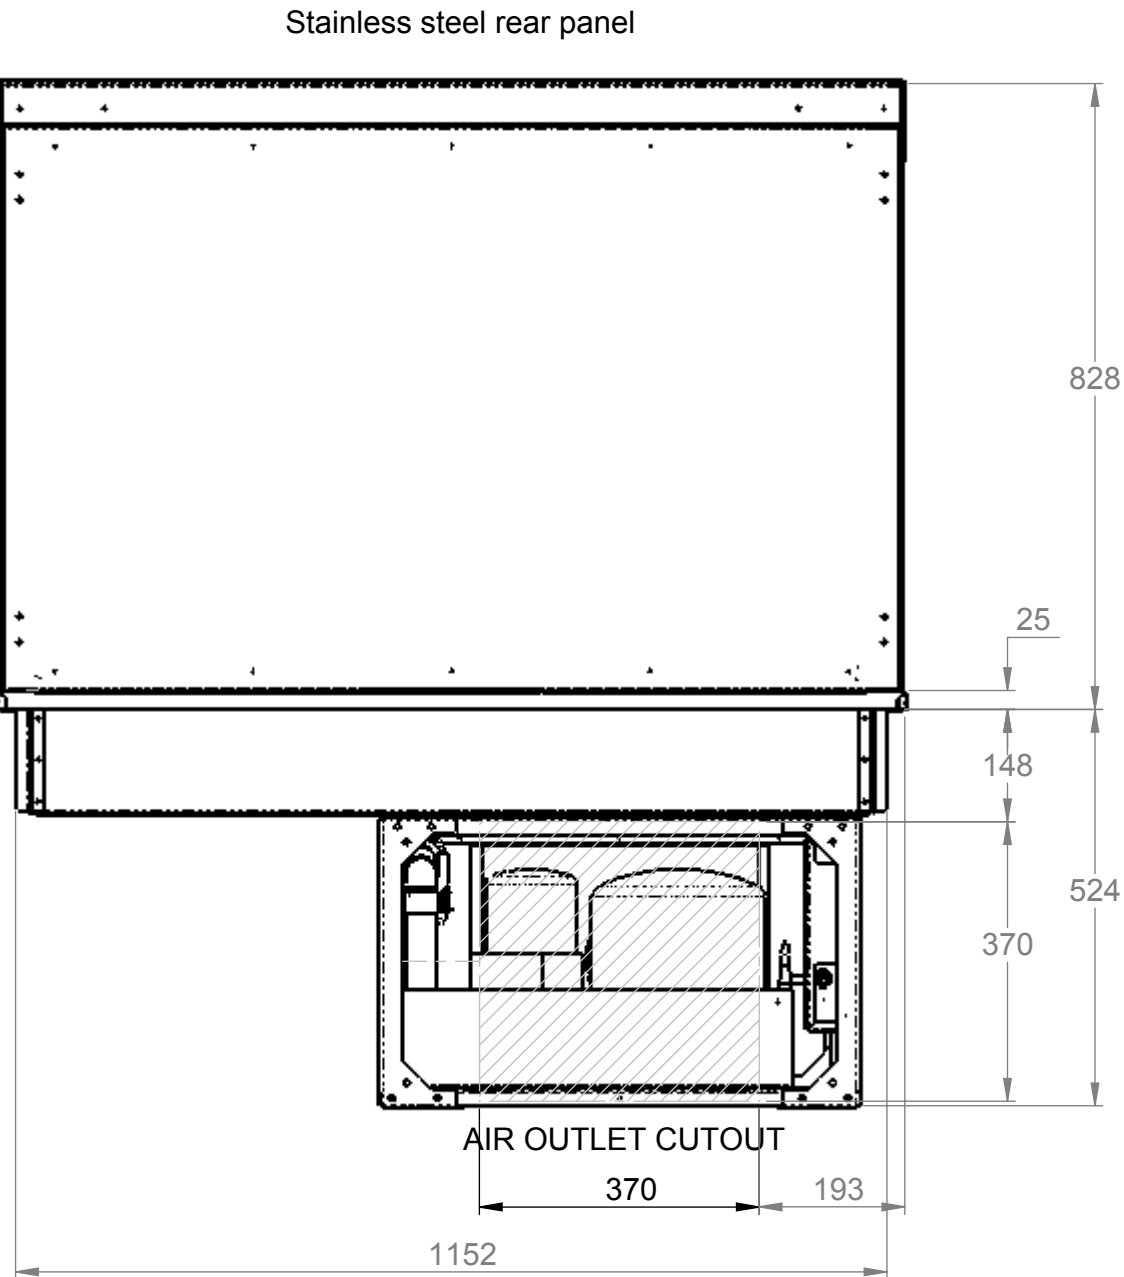

Rear elevation

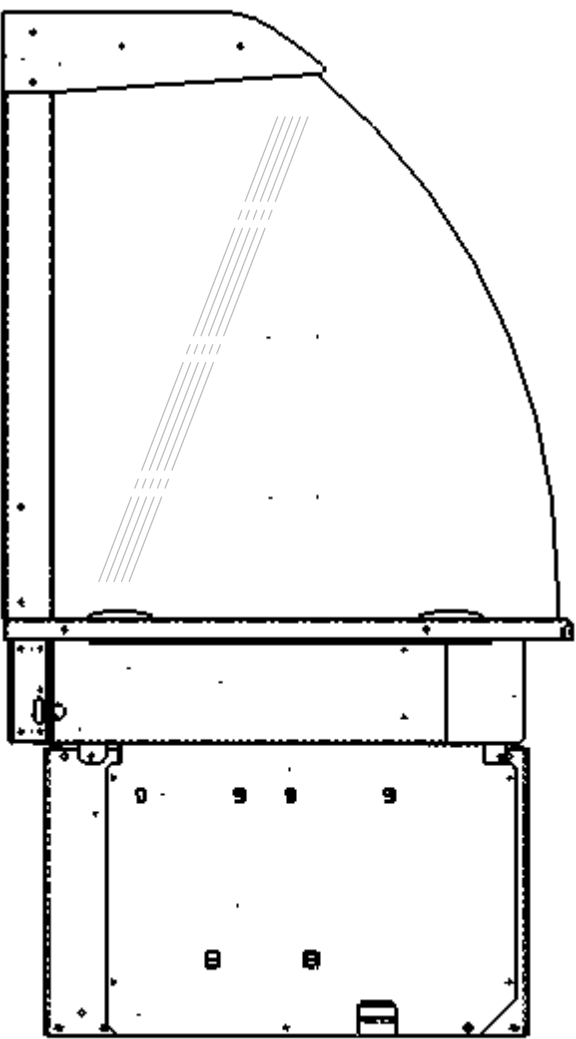

End elevation

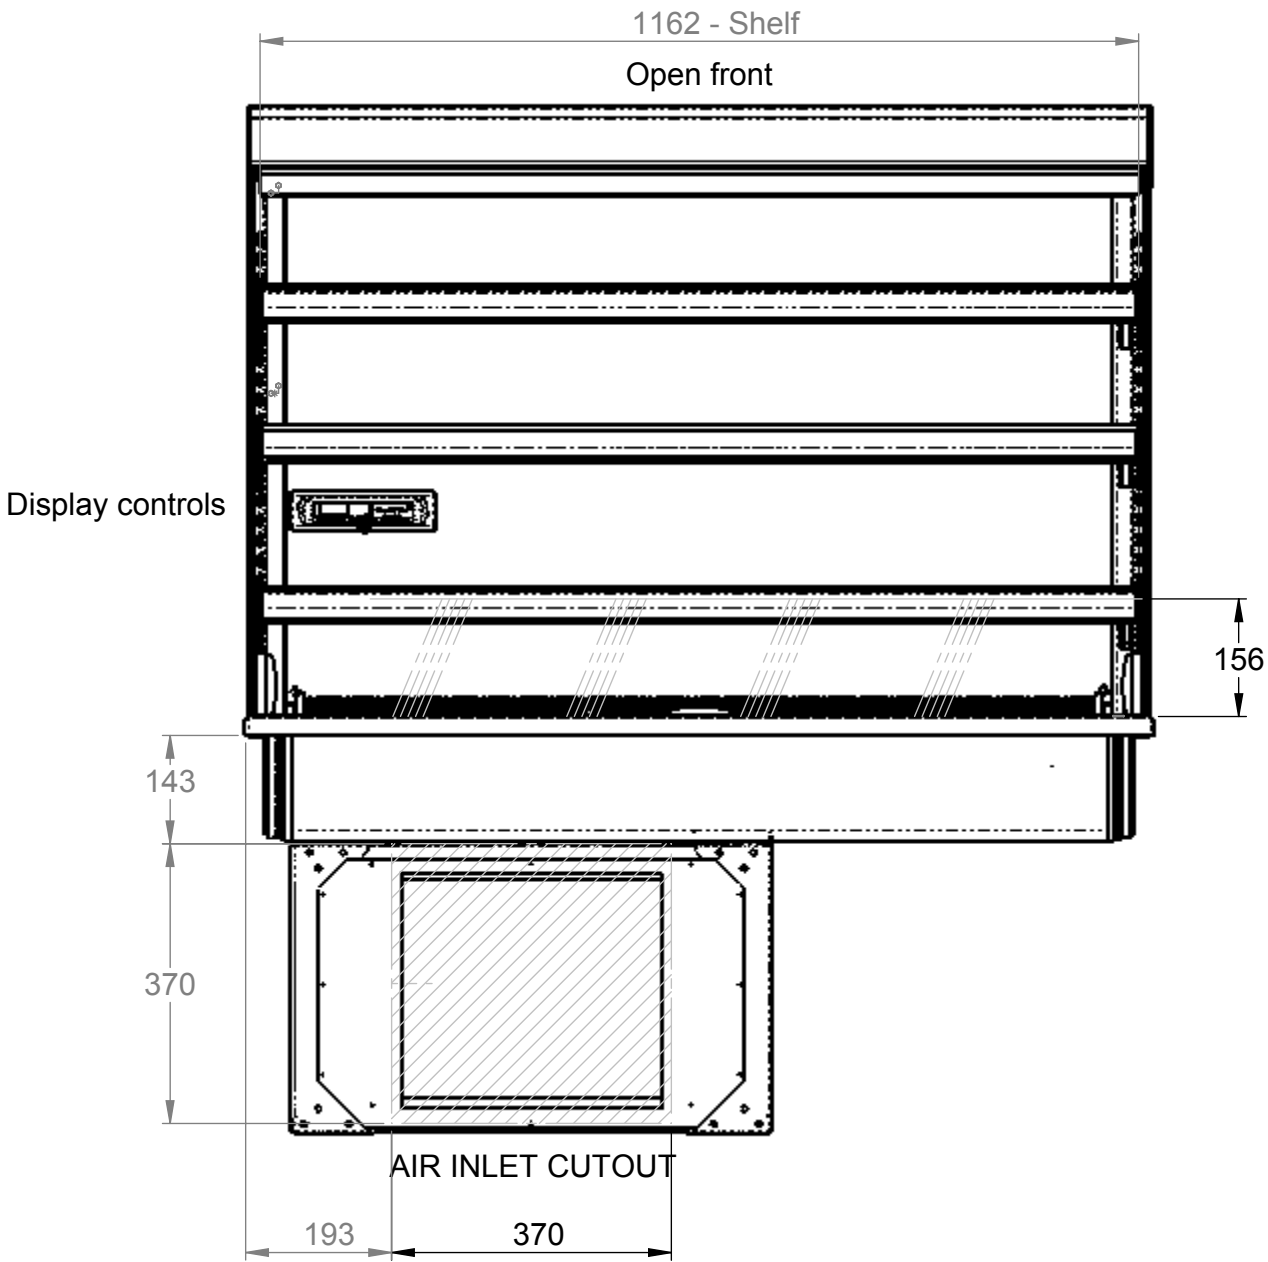


Front elevation

Electrical Spec - 13A, 230V, 2.8Kw
via 13A plug top on 2.5 Metre lead
Weight - 210Kg Approx

Assembly No - VOCDI1200-GC

Stainless steel air inlet-outlet grille details

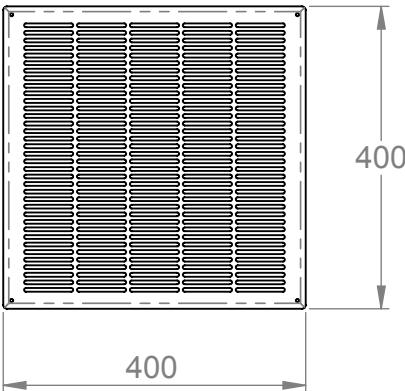

Issue	Date	Description
counterline Randles Rd, Knowsley Business Park, Merseyside L34 9HZ. Tel: 0151 548 2211 Fax: 0151 549 2179		
Title: Vision Open Chilled Display 1200 Fixed Back		
Drg No :	Issue:	Date: 23/03/2015
14-249--A		Scale: 1:10 @ A2
Drn by: G Burgess		Chk'd:
All dims in MM		Date: