

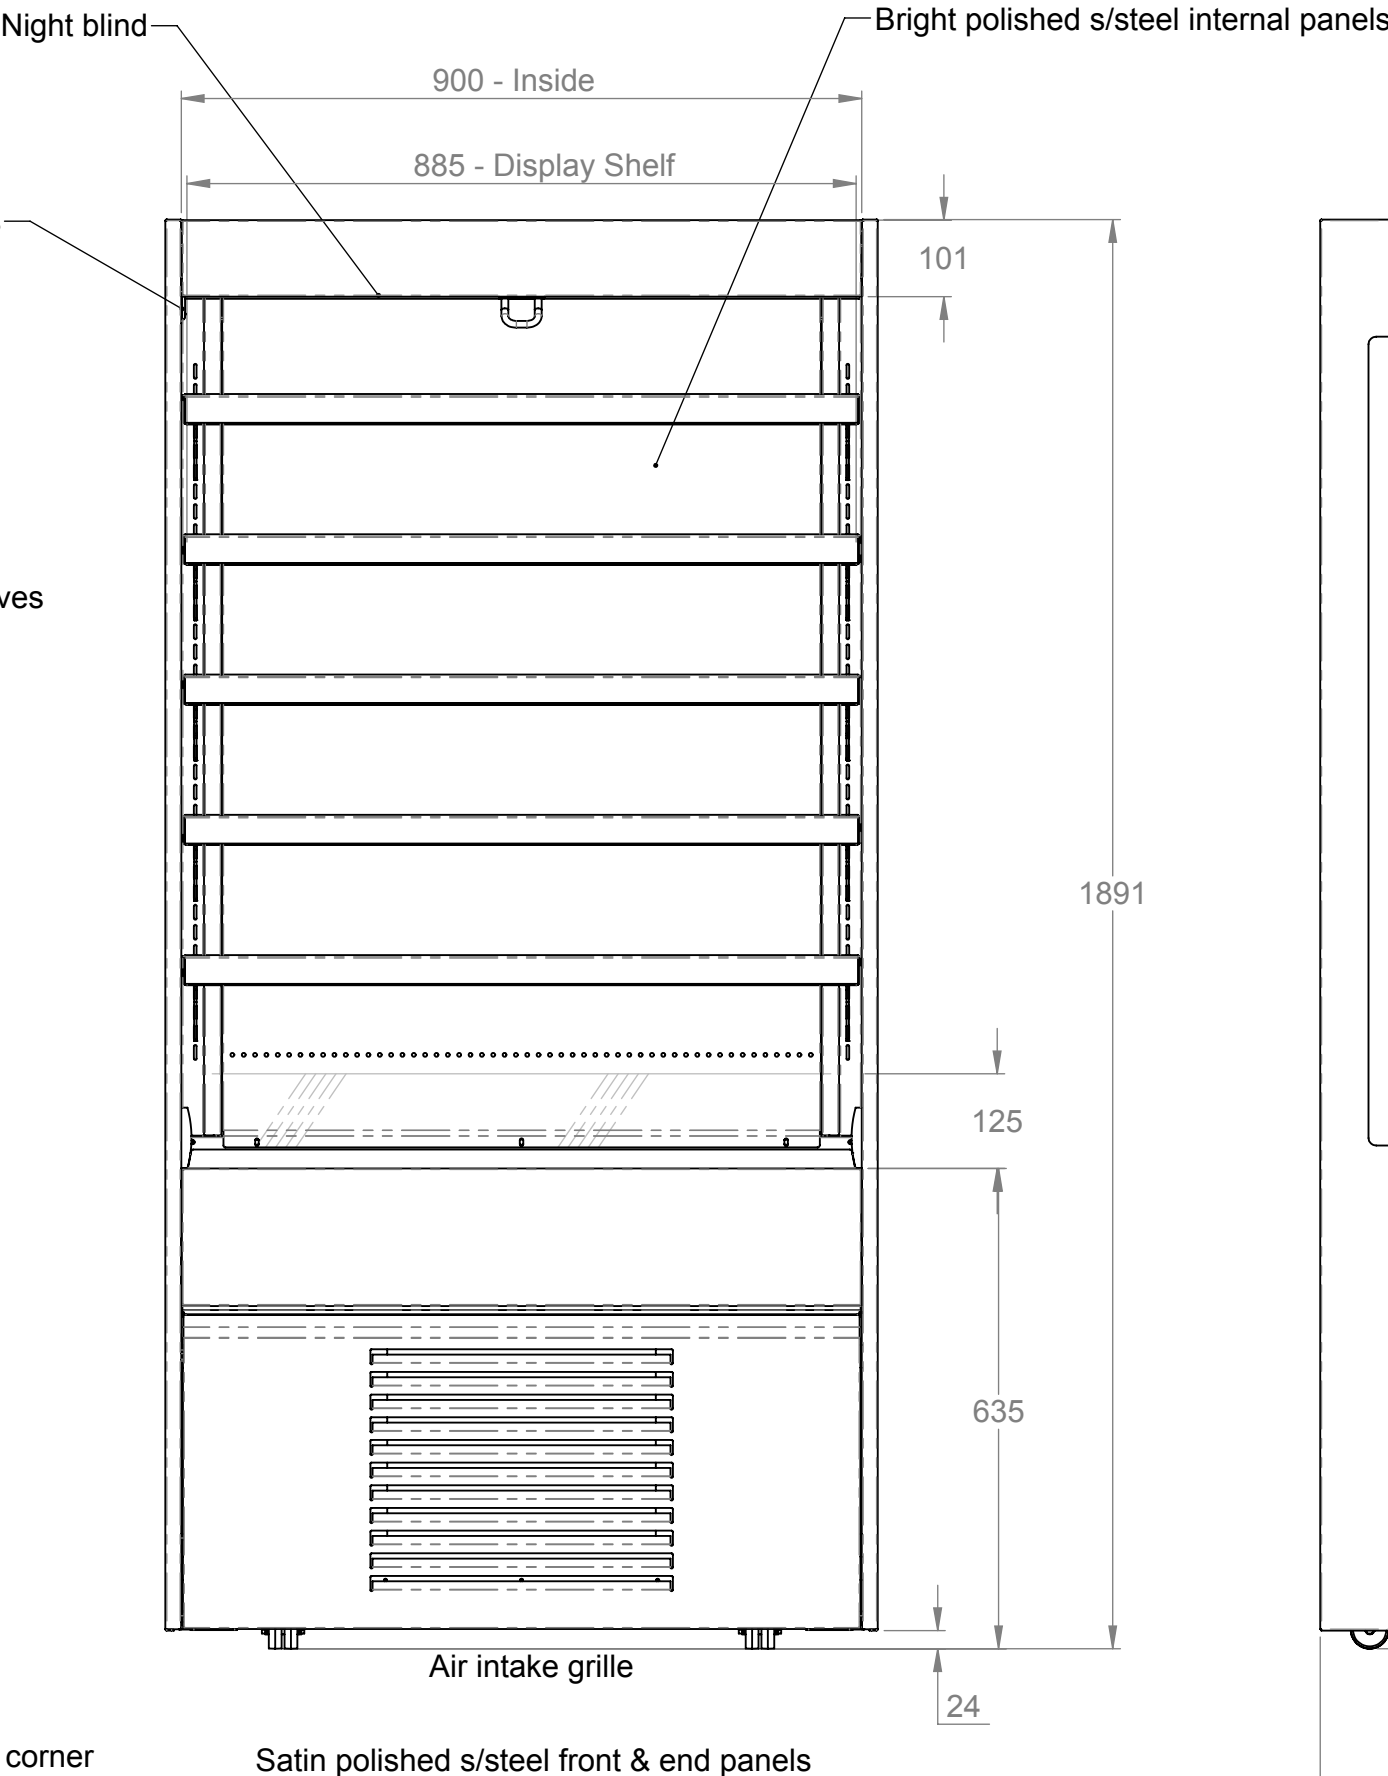



Plan

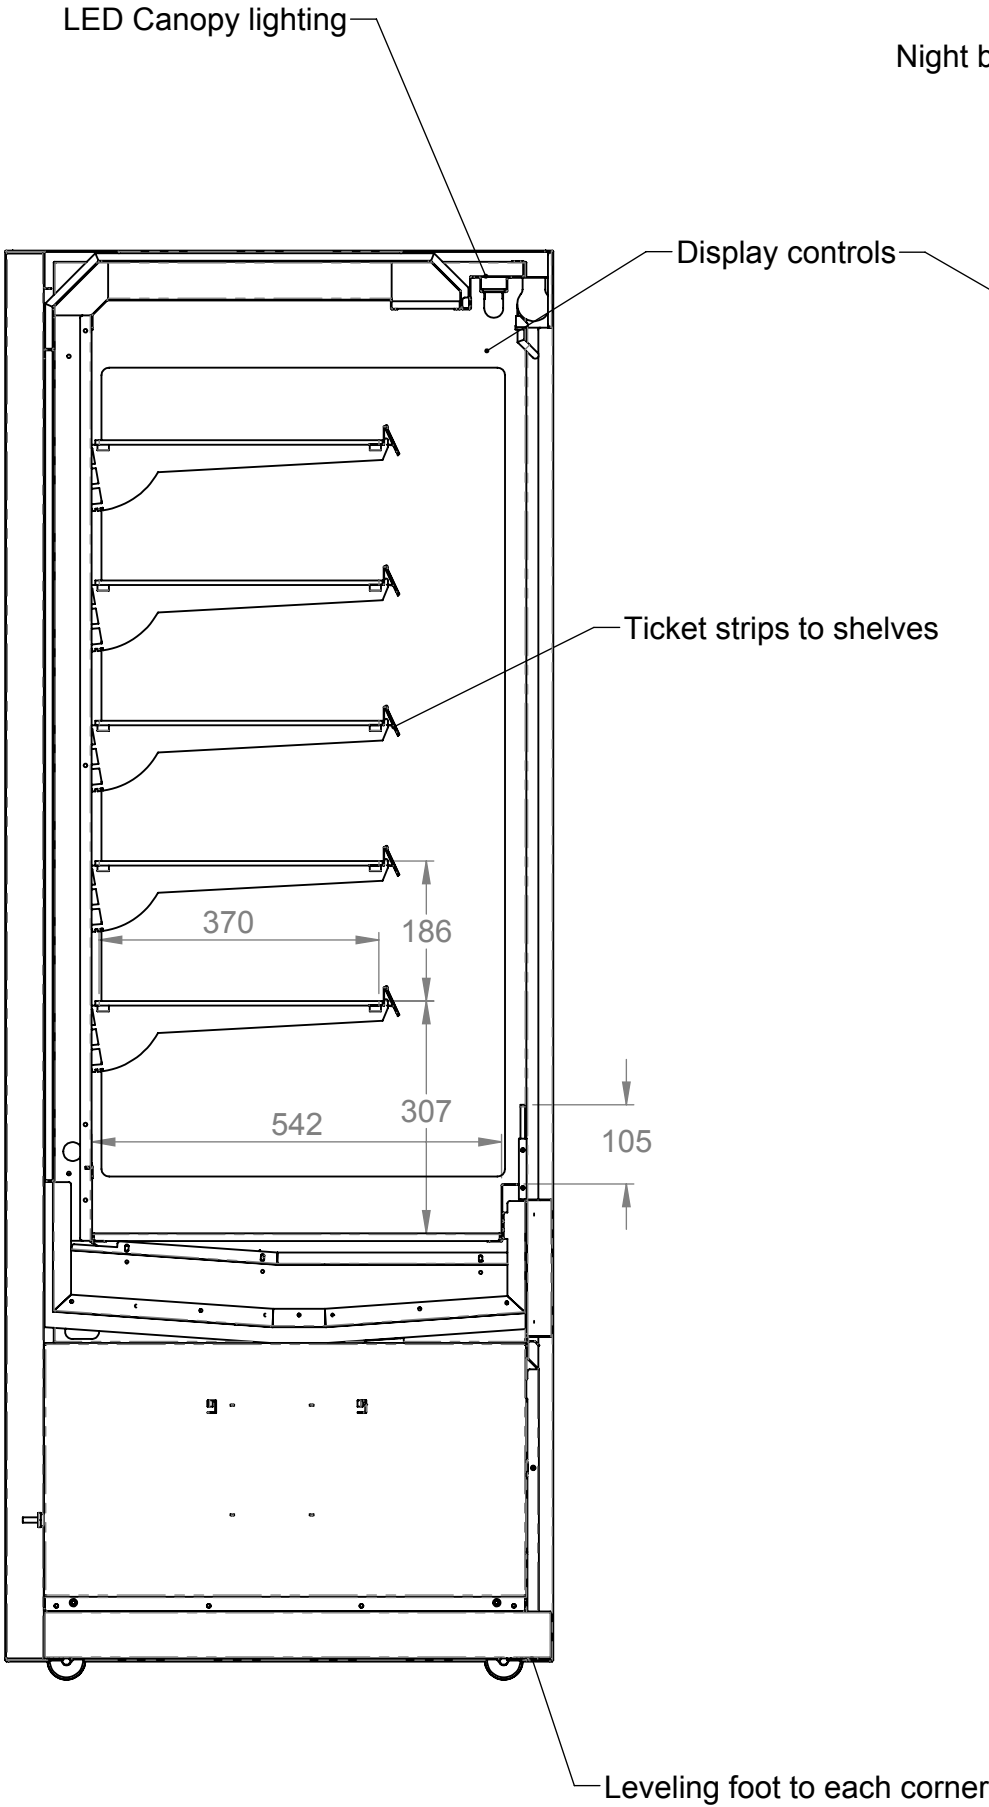

Front elevation

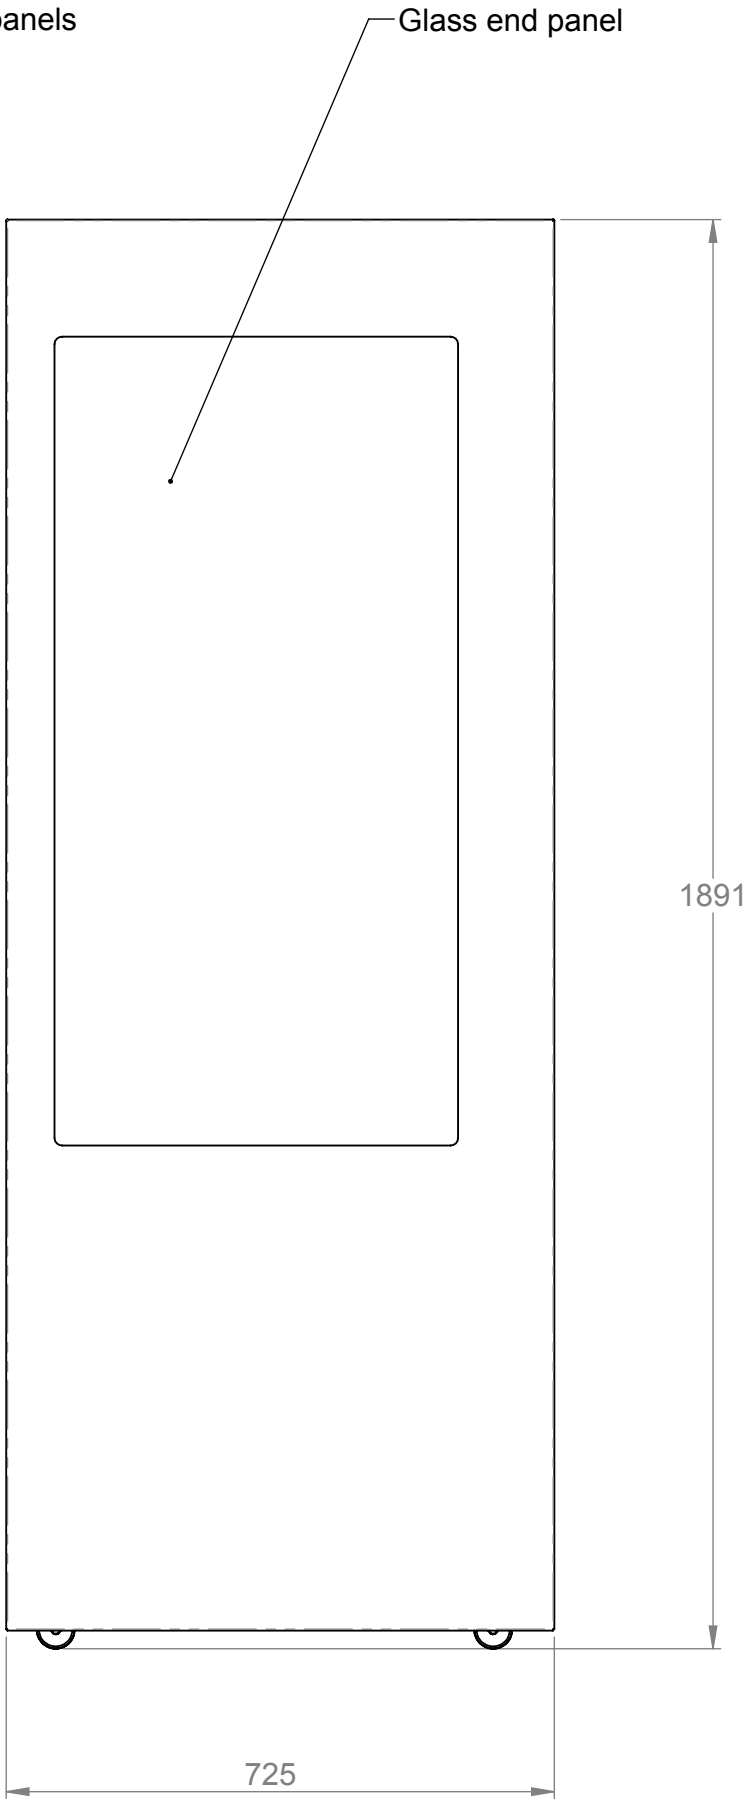

End elevation

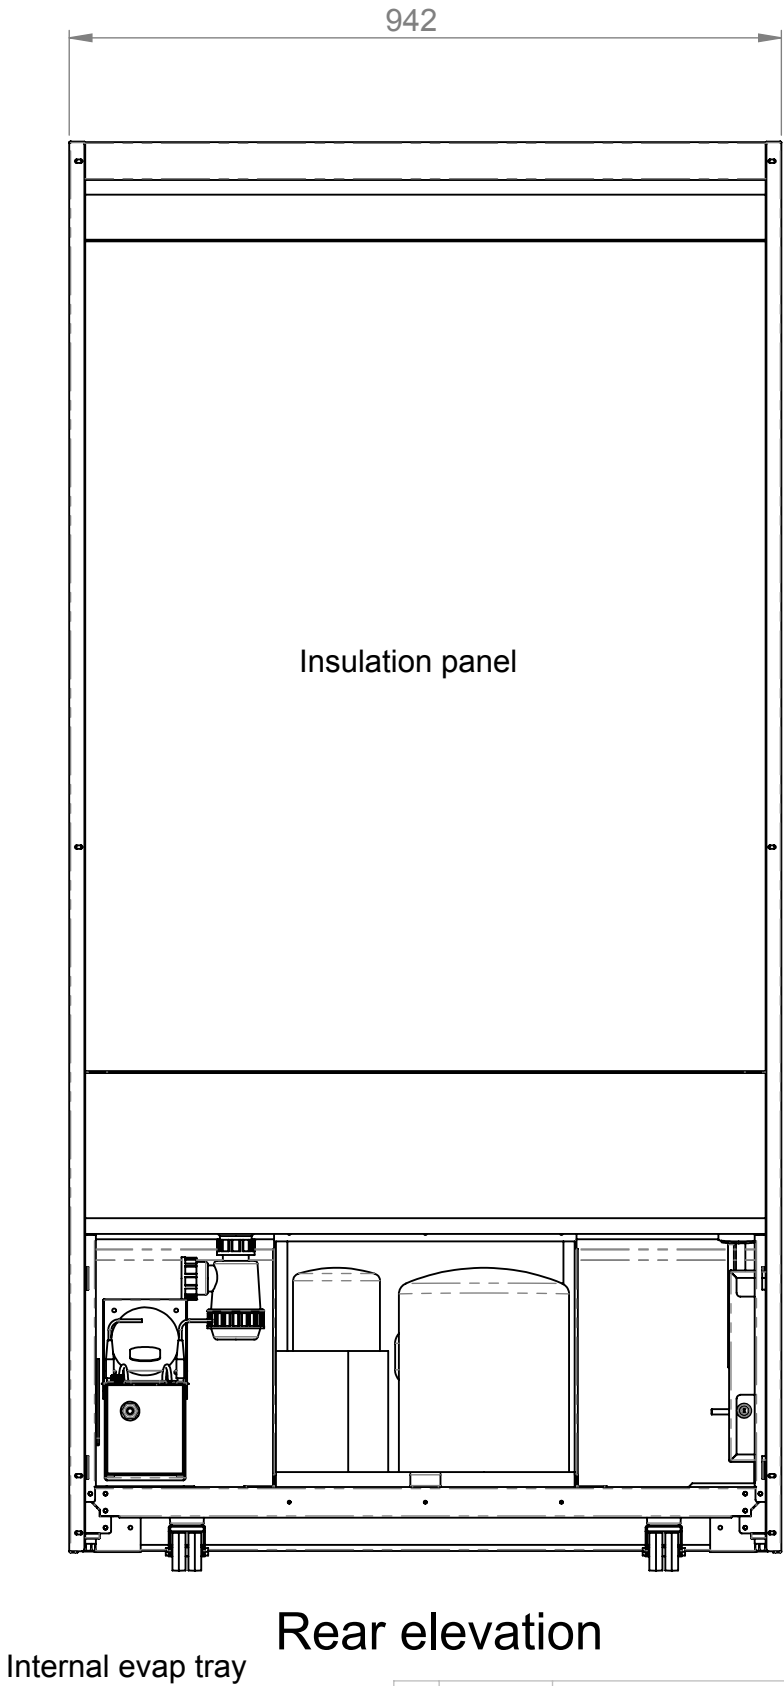

Rear elevation

ELECTRICAL SPEC - 13A, 230V, 2.7Kw
Via 13 Amp plugtop on 2.5 Metre lead
Weight - 200 Kg Approx

Assembly No - CHCTMD09-NB-GE

Issue	Date	Description
<div>counterline</div> <div>Randles Rd, Knowsley Business Park, Merseyside L34 9HZ. Tel: 0151 548 2211 Fax: 0151 549 2179</div>		
Title: Chilled Tall Multi Tier 900		
Drg No : 16-124--A		Issue: Date: 12/05/2016
Dn by: G Burgess		Scale: 1:10 @ A2
All dims in MM		Chk'd: Date: